

NOTE:

PURSUANT TO SECTION 4 OF ANNEX "A" OF THE REVISED IMPLEMENTING RULES AND REGULATION OF R.A. 9164, APPROVAL BY THE AUTHORIZED DPWH OFFICIALS OF DETAILED ENGINEERING SURVEYS AND DESIGN UNDERTAKEN BY CONSULTANTS NEITHER DIMINISHES THE RESPONSIBILITY OF THE LATTER FOR THE TECHNICAL INTEGRITY OF THE SURVEYS AND DESIGN NOR TRANSFER ANY PART OF THAT RESPONSIBILITY TO THE APPROVING OFFICIALS.

THE DESIGN CONSULTANT SHALL BE HELD RESPONSIBLE FOR THE FAILURE OF THE FACILITY/IES / STRUCTURES DUE TO FAULTY DESIGN EXCEPT FOR THE CHANGES MADE WITHOUT THE CONFORMITY OF THE CONSULTANTS.

DRAWINGS AND SPECIFICATIONS DULY SIGNED, STAMPED OR SEALED, AS INSTRUMENTS OF SERVICE, ARE PROPERTY AND DOCUMENTS OF THE ARCHITECT. WHETHER THE OBJECT FOR WHICH THEY ARE MADE, IS EXECUTED OR NOT, IT SHALL BE UNLAWFUL FOR ANY PERSON, WITHOUT THE WRITTEN CONSENT OF THE ARCHITECT OR AUTHOR OF SAID DOCUMENTS, TO DUPLICATE OR TO MAKE COPIES OF SAID DOCUMENTS FOR USE IN THE REPERITION OF AND FOR OTHER PROJECTS OR BUILDINGS, WHETHER EXECUTED PARTLY OR IN WHOLE.

LEGEND

ITEM	SYMBOL	DESCRIPTION	QTY	UNIT	HOSE RADIUS	SYMBOL	TYPE
1.0	OCV	QUICK COUPLING VALVE (MANUAL IRRIGATION)	8	PCS	15 METERS	HOSE EXTENT	
2.0	RN	ROTARY NOZZLE (AUTOMATIC IRRIGATION)	23	PCS	5 METERS	SPRINKLER	
3.0	ADP	AREA DRAIN ON PAVE SURFACE	13	PCS			
4.0	PLD	PLANTER DRAIN	53	PCS			
5.0	LAD	LAWN AREA DRAIN	12	PCS			
6.0	DTD	DECORATIVE TRENCH DRAIN	127	LM			
7.0	PP	PERFORATED PIPE	365	LM			
8.0	DL	DRIP LINE	164	LM			
9.0	SLOPE	DIRECTION OF SLOPE					

NOTE: IF NOT INDICATED, ASSUME SLOPE IS 2% FROM EDGES TO DRAIN LOCATIONS.

EAST AVENUE

PSA 23-STORY BUILDING
GROUND FLOOR DRAINAGE AND IRRIGATION LAYOUT

SCALE 1:100M



PSA 23-STOREY BUILDING
7TH FLOOR DRAINAGE AND IRRIGATION LAYOUT

SCALE 1:100M

NOTE:

PURSUANT TO SECTION 4 OF ANNEX "A" OF THE REVISED IMPLEMENTING RULES AND REGULATION OF R.A. 9164, APPROVAL BY THE AUTHORIZED DPWH OFFICIALS OF DETAILED ENGINEERING SURVEYS AND DESIGN UNDERTAKEN BY CONSULTANTS NEITHER DIMINISHES THE RESPONSIBILITY OF THE LATTER FOR THE TECHNICAL INTEGRITY OF THE SURVEYS AND DESIGN NOR TRANSFER ANY PART OF THAT RESPONSIBILITY TO THE APPROVING OFFICIALS.

THE DESIGN CONSULTANT SHALL BE HELD RESPONSIBLE FOR THE FAILURE OF THE FACILITY/IES / STRUCTURES DUE TO FAULTY DESIGN EXCEPT FOR THE CHANGES MADE WITHOUT THE CONFORMITY OF THE CONSULTANTS.

DRAWINGS AND SPECIFICATIONS DULY SIGNED, STAMPED OR SEALED, AS INSTRUMENTS OF SERVICE, ARE PROPERTY AND DOCUMENTS OF THE ARCHITECT. WHETHER THE OBJECT FOR WHICH THEY ARE MADE IS EXECUTED OR NOT, IT SHALL BE UNLAWFUL FOR ANY PERSON, WITHOUT THE WRITTEN CONSENT OF THE ARCHITECT OR AUTHOR OF SAID DOCUMENTS, TO DUPLICATE OR TO MAKE COPIES OF SAID DOCUMENTS FOR USE IN THE REPEITION OF AND FOR OTHER PROJECTS OR BUILDINGS, WHETHER EXECUTED PARTLY OR IN WHOLE.

TOKWING CONSTRUCTION CORPORATION
Lod 35, Rodriguez Drive, Rodriguez Subdivision,
Davao, Davao City
Tel No. (832) 8961 6069 Email: tokwingcorp@yahoo.com.ph

ENRIQUE O. OLANAN & ASSOCIATES
ARCHITECTS ENGINEERS CONSULTANTS
Suite 305, Xavierville Square Condominium,
No. 38 Xavierville Ave. Lapad Heights, Quezon City
Tel No. (832) 7917 5358 Email: eolanandesign@gmail.com

CONSULTANT: ERIC V. ESTORIDO
LANDSCAPE ARCHITECT
PRC NO. : 196 VALIDITY : 01/31/2023
PTR NO. : 0769596 DATE : 01/26/2022
PLACE : BRGA CITY TN NO. : 303-286-105

CHECKED: JOSE MANUEL AGUIBALDO
PROJECT MANAGER II
BUILDING & SPECIAL PROJECTS MANAGEMENT CLUSTER
UNIFIED PROJECT MANAGEMENT OFFICE, DPWH

REVIEWED: ATTY. JOHNSON V. DOMINCO
PROJECT DIRECTOR
BUILDING & SPECIAL PROJECTS MANAGEMENT CLUSTER
UNIFIED PROJECT MANAGEMENT OFFICE, DPWH

RECOMMENDING APPROVAL: REYNOR P. IMPERIAL
DIRECTOR II
PLANNING AND MANAGEMENT SERVICE
CO-HEAD, PSA-BOCM

SOCRATES L. RAMORES
DIRECTOR IV
FINANCE AND ADMINISTRATIVE SERVICE
HEAD, PSA-BOCM

LEO B. MALAGAR
ASSISTANT SECRETARY
DEPUTY NATIONAL STATISTICIAN
CIVIL REGISTRATION & CENTRAL SUPPORT OFFICE
NATIONAL STATISTICIAN AND CIVIL REGISTRAR GENERAL
PHILIPPINE STATISTICS AUTHORITY

APPROVED: USEIC, CLAIRE DENNIS B. MAPA, PH. D.
NATIONAL STATISTICIAN AND CIVIL REGISTRAR GENERAL
PHILIPPINE STATISTICS AUTHORITY


PROJECT: CONSTRUCTION OF FIT-OUT AND LANDSCAPE WORKS FOR THE
TWENTY-THREE (23) STOREY PHILIPPINE STATISTICS AUTHORITY (PSA)
OFFICE BUILDING WITH COVERED ROOF DECK
LOCATION: PSA COMPLEX, EAST AVENUE, DILIMAN, QUEZON CITY

SHEET CONTENT: DRAINAGE PLAN AND IRRIGATION LAYOUT

DESIGNER : EVE
EAD : JRC
CHECKED : EVE
DATE : FEB. 22, 2022

REVISIONS
SYMBOL REMARK DATE

SHEET NO.
LA-06B

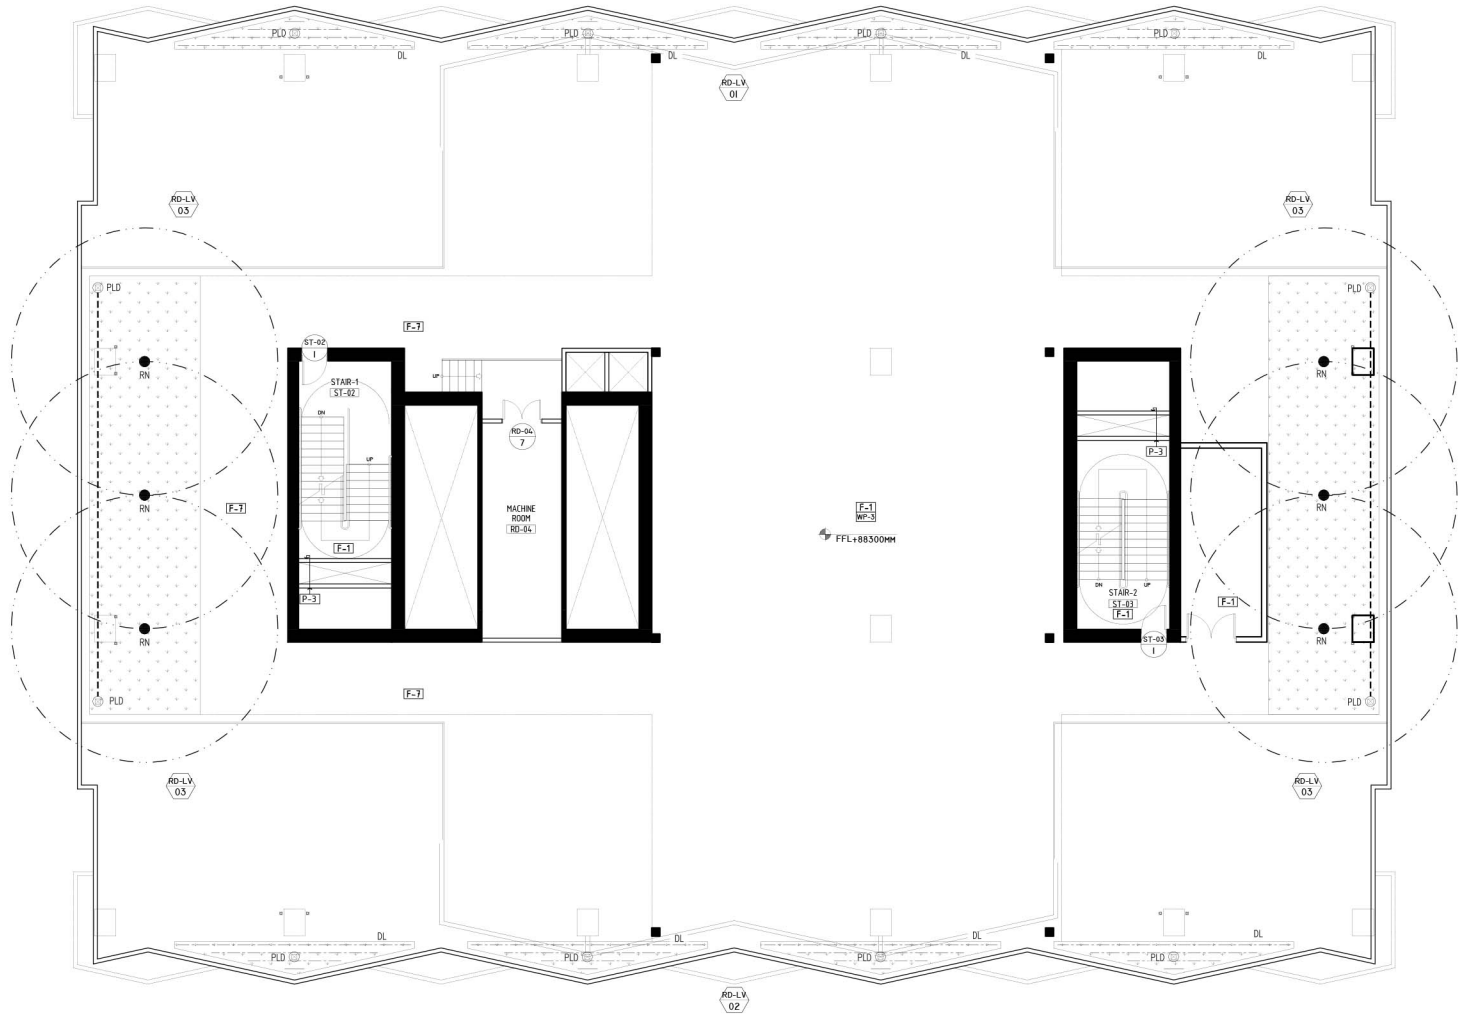

NOTE:
PURSUANT TO SECTION 4 OF ANNEX "A" OF THE REVISED IMPLEMENTING RULES AND REGULATION OF R.A. 9164, APPROVAL BY THE AUTHORIZED DPWH OFFICIALS OF DETAILED ENGINEERING SURVEYS AND DESIGN UNDERTAKEN BY CONSULTANTS NEITHER DIMINISHES THE RESPONSIBILITY OF THE LATTER FOR THE TECHNICAL INTEGRITY OF THE SURVEYS AND DESIGN NOR TRANSFER ANY PART OF THAT RESPONSIBILITY TO THE APPROVING OFFICIALS.
THE DESIGN CONSULTANT SHALL BE HELD RESPONSIBLE FOR THE FAILURE OF THE FACILITY/IES / STRUCTURES DUE TO FAULTY DESIGN EXCEPT FOR THE CHANGES MADE WITHOUT THE CONFORMITY OF THE CONSULTANTS.

DRAWINGS AND SPECIFICATIONS DULY SIGNED, STAMPED OR SEALED, AS INSTRUMENTS OF SERVICE, ARE PROPERTY AND DOCUMENTS OF THE ARCHITECT, WHETHER THE OBJECT FOR WHICH THEY ARE MADE IS EXECUTED OR NOT. IT SHALL BE UNLAWFUL FOR ANY PERSON, WITHOUT THE WRITTEN CONSENT OF THE ARCHITECT OR AUTHOR OF SAID DOCUMENTS, TO DUPLICATE OR TO MAKE COPIES OF SAID DOCUMENTS FOR USE IN THE REPRODUCTION OF AND FOR OTHER PROJECTS OR BUILDINGS, WHETHER EXECUTED PARTLY OR IN WHOLE.

PSA 23-STOREY BUILDING
ROOF DECK DRAINAGE AND IRRIGATION LAYOUT

SCALE 1:100M

TOKWING
CONSTRUCTION CORPORATION
Lor 35, Rodriguez Drive, Rodriguez Subdivision,
Quezon City
Tel No. (632) 8961 6969 Email: tokwingcorp@yahoo.com.ph

ENRIQUE O. OLANAN & ASSOCIATES
ARCHITECTS ENGINEERS CONSULTANTS
Suite 305, Xaveriaville Square Condominium,
No. 38 Xaveriaville Ave. Lapad Heights, Quezon City
Tel No. (632) 7217 5358 Email: eolanandesign@gmail.com

CONSULTANT:
ERIC V. ESTORIDO
LANDSCAPE ARCHITECT
PRC NO. : 196
DATE : 01/21/2023
PLACE : BRGA CITY
TN NO. : 303-286-105

CHECKED:
JOSE MANUEL AGUIBALDO
PROJECT MANAGER II
BUILDING & SPECIAL PROJECTS MANAGEMENT CLUSTER
UNIFIED PROJECT MANAGEMENT OFFICE, DPWH

REVIEWED:
ATTY. JOHNSON V. DOMINCO
PROJECT DIRECTOR
BUILDING & SPECIAL PROJECTS MANAGEMENT CLUSTER
UNIFIED PROJECT MANAGEMENT OFFICE, DPWH

RECOMMENDING APPROVAL:
REYNOR R. IMPERIAL
DIRECTOR II
PLANNING AND MANAGEMENT SERVICE
CO-HEAD, PSA-BCOM

SOCRATES L. RAMORES
DIRECTOR IV
ASSISTANT NATIONAL STATISTICIAN
FINANCE AND ADMINISTRATIVE SERVICE
HEAD, PSA-BCOM

LEO B. MALAGAR
ASSISTANT SECRETARY
DEPUTY NATIONAL STATISTICIAN
CIVIL REGISTRATION & CENTRAL SUPPORT OFFICE

APPROVED:
USEIG, CLAIRE DENNIS B. MAPA, PH. D.
NATIONAL STATISTICIAN AND CIVIL REGISTRAR GENERAL
PHILIPPINE STATISTICS AUTHORITY

PROJECT:
CONSTRUCTION OF FIT-OUT AND LANDSCAPE WORKS FOR THE
TWENTY-THREE (23) STOREY PHILIPPINE STATISTICS AUTHORITY (PSA)
OFFICE BUILDING WITH COVERED ROOF DECK
LOCATION: PSA COMPLEX, EAST AVENUE, DILIMAN, QUEZON CITY

SHEET CONTENT
DRAINAGE PLAN AND IRRIGATION LAYOUT

DESIGNER : EVE
CAD : JRC
CHECKED : EVE
DATE : FEB. 22, 2022

REVISIONS
SYMBOL REMARK DATE

SHEET NO.
LA-06C