



ELECTRICAL PLANS

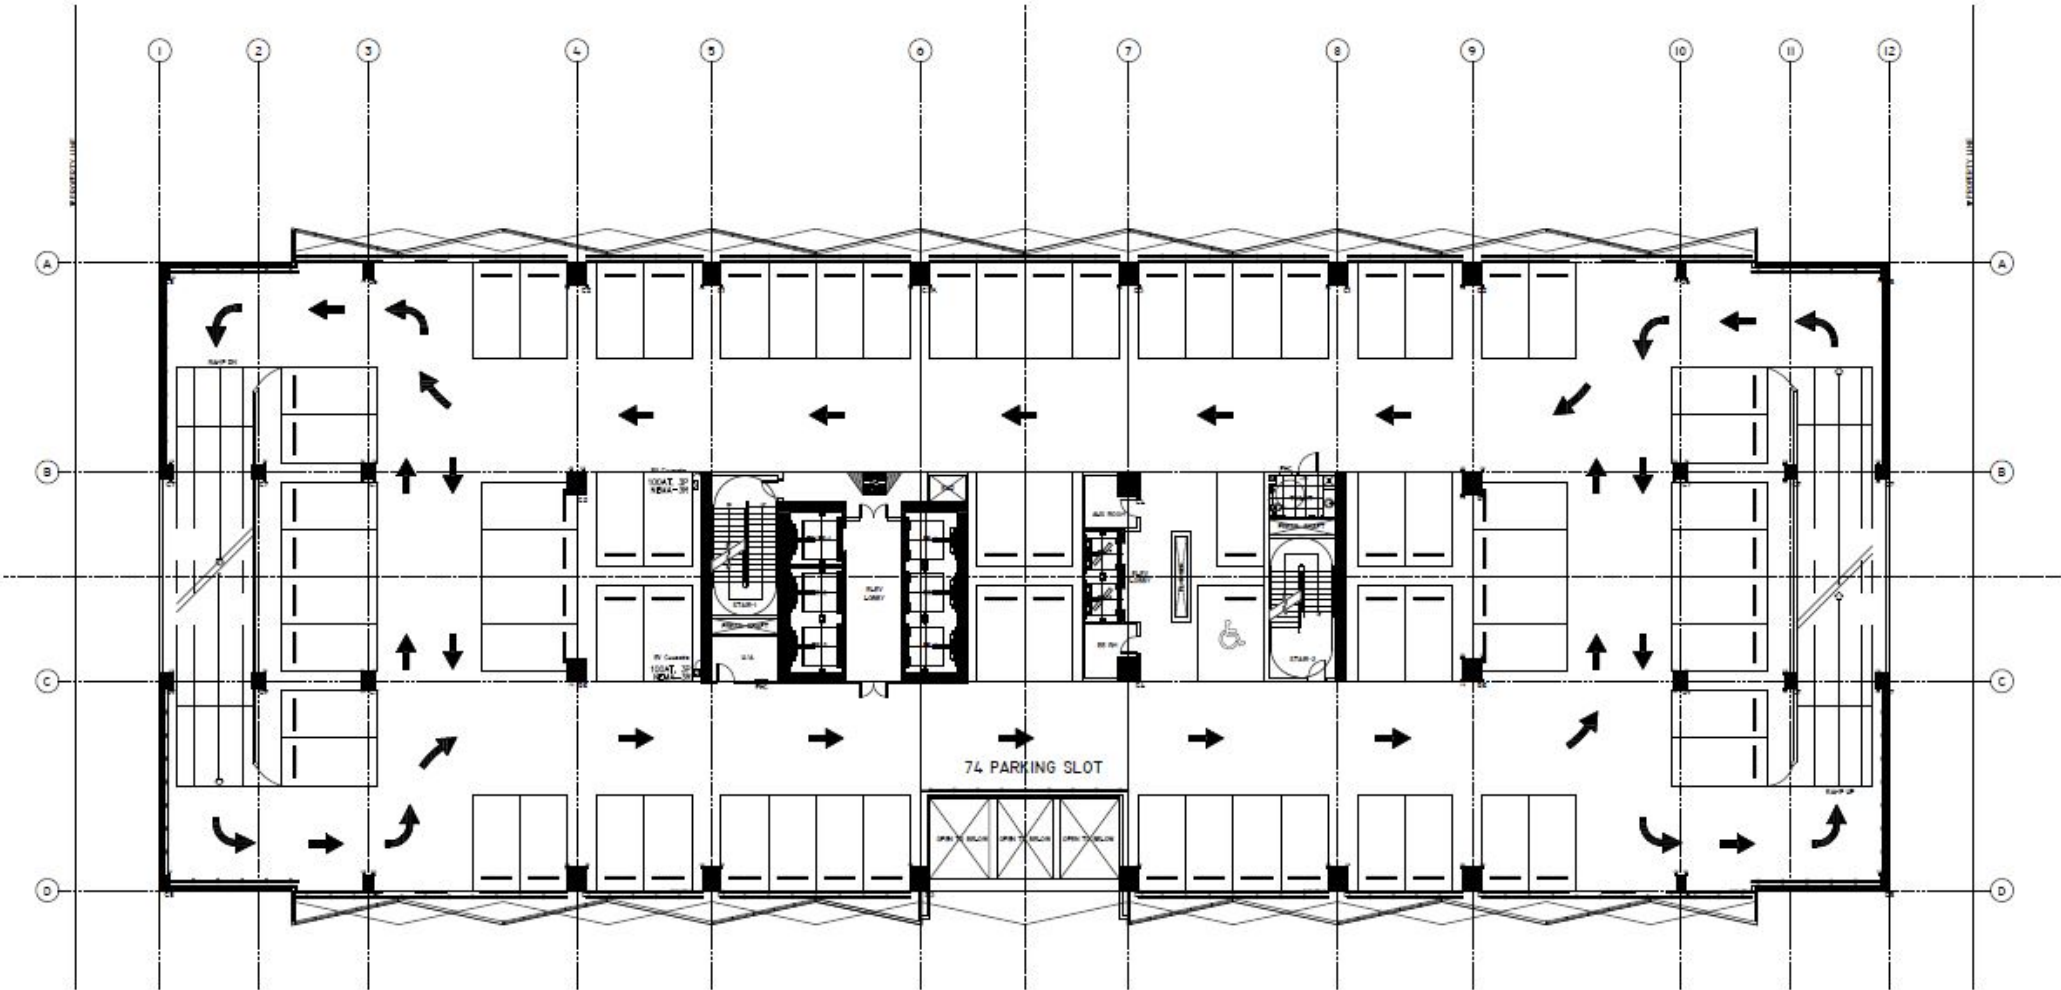

POWER LAYOUT  
SCALE: 1:200 MTS

4TH FLOOR

## ELECTRICAL PLANS

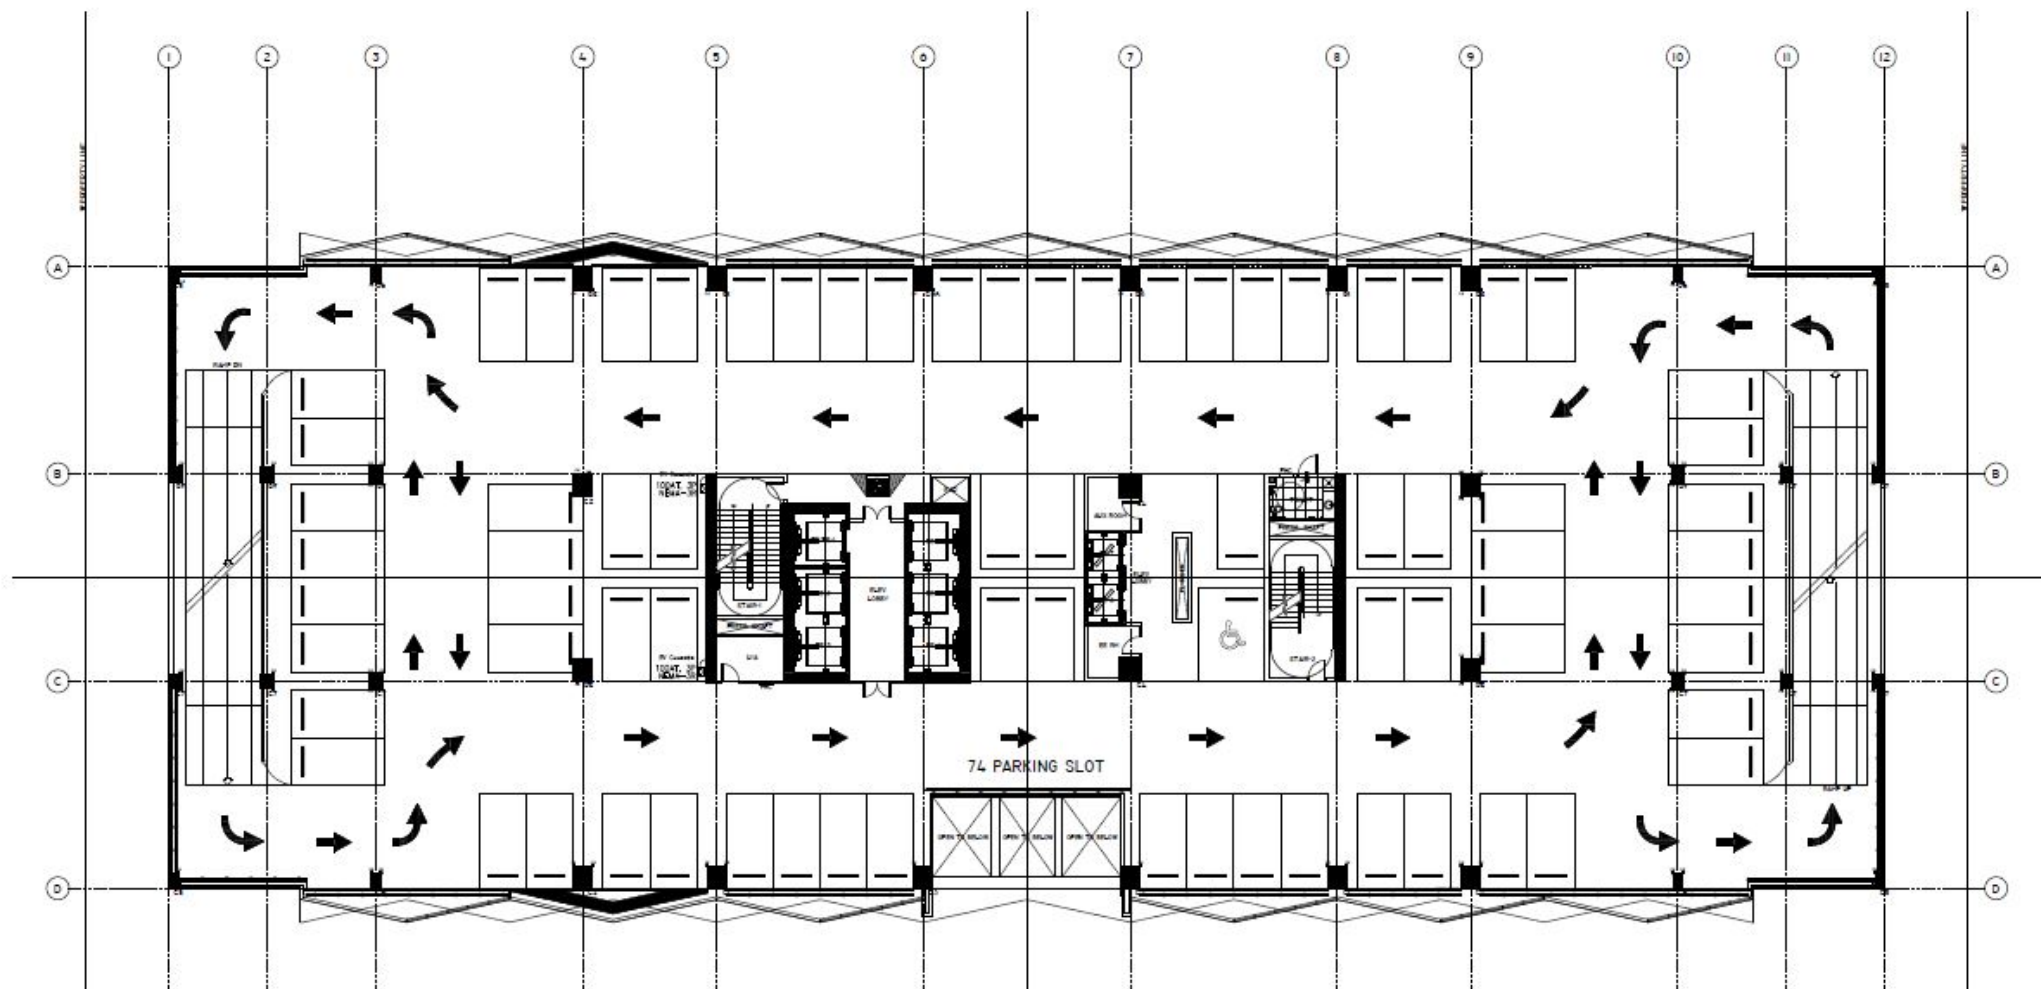


## POWER LAYOUT

SCALE:

1:200 MTS

5TH FLOOR


ELECTRICAL PLANS

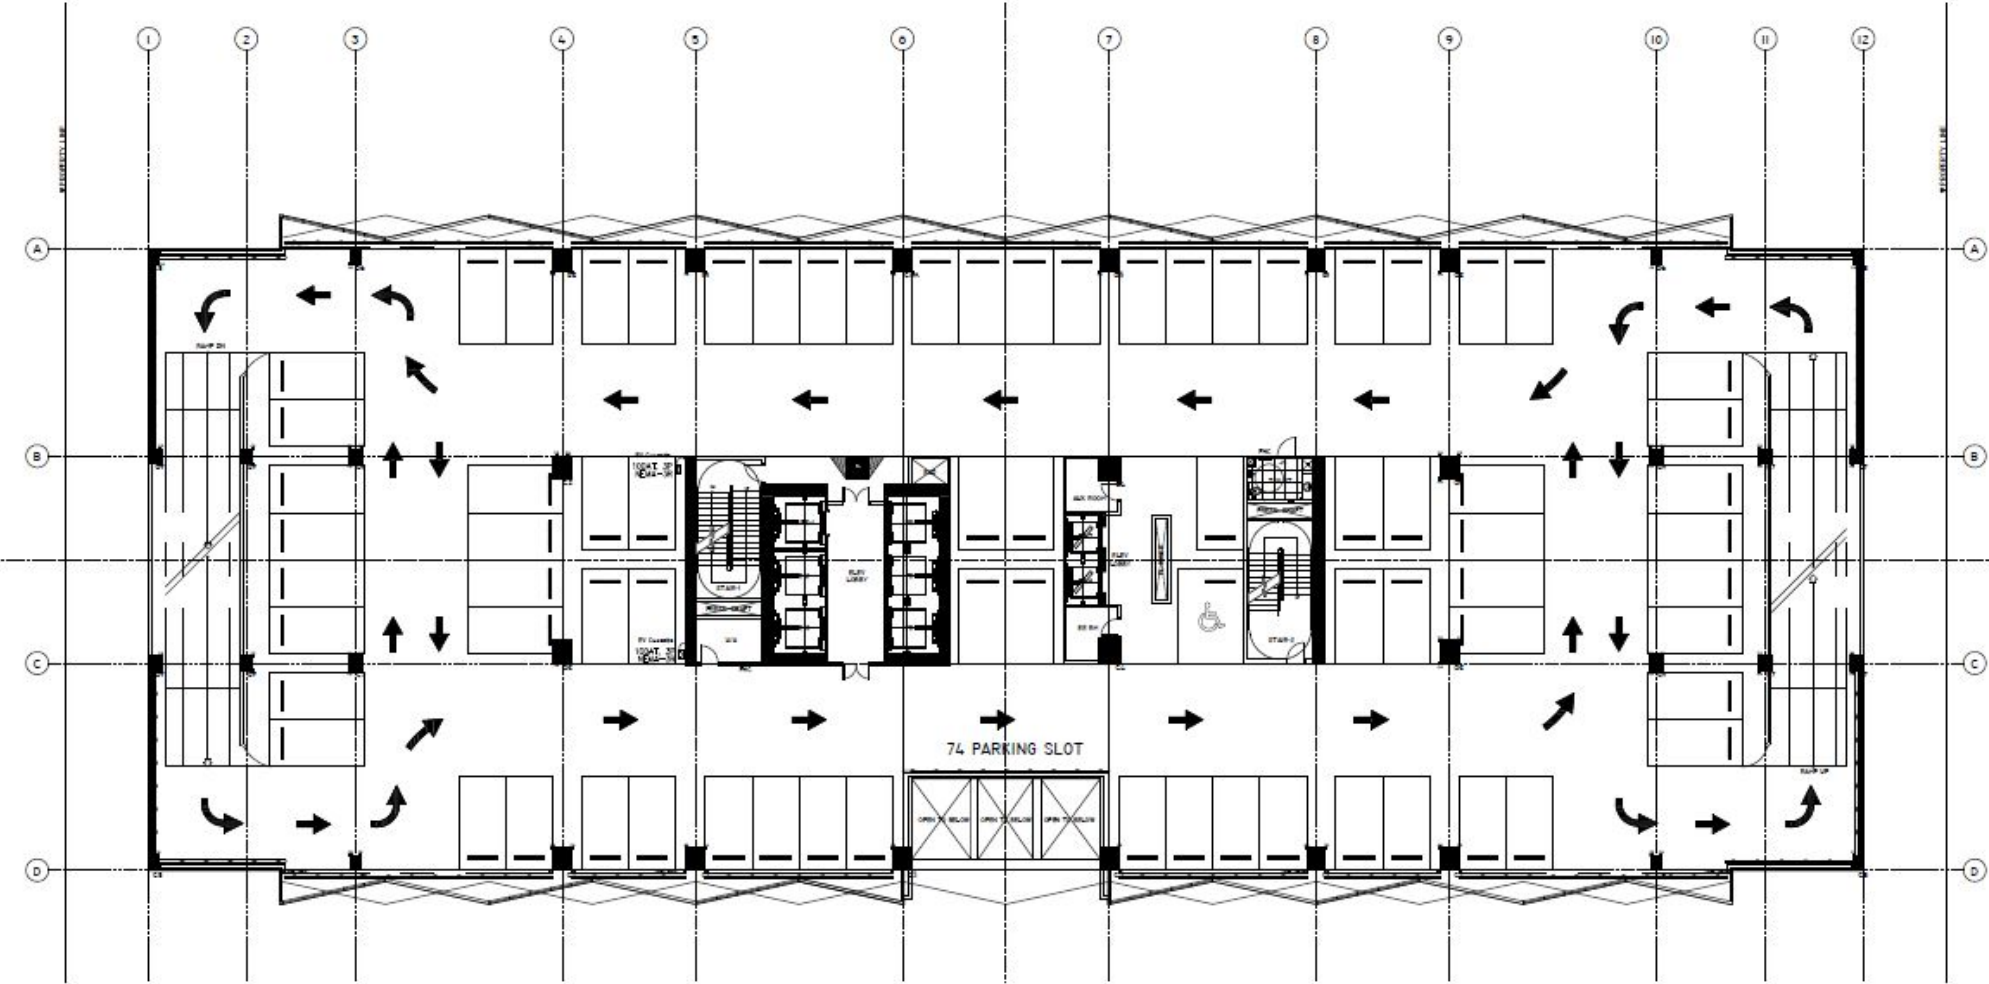

POWER LAYOUT  
SCALE: 1:200 MTS

6TH FLOOR

## ELECTRICAL PLANS

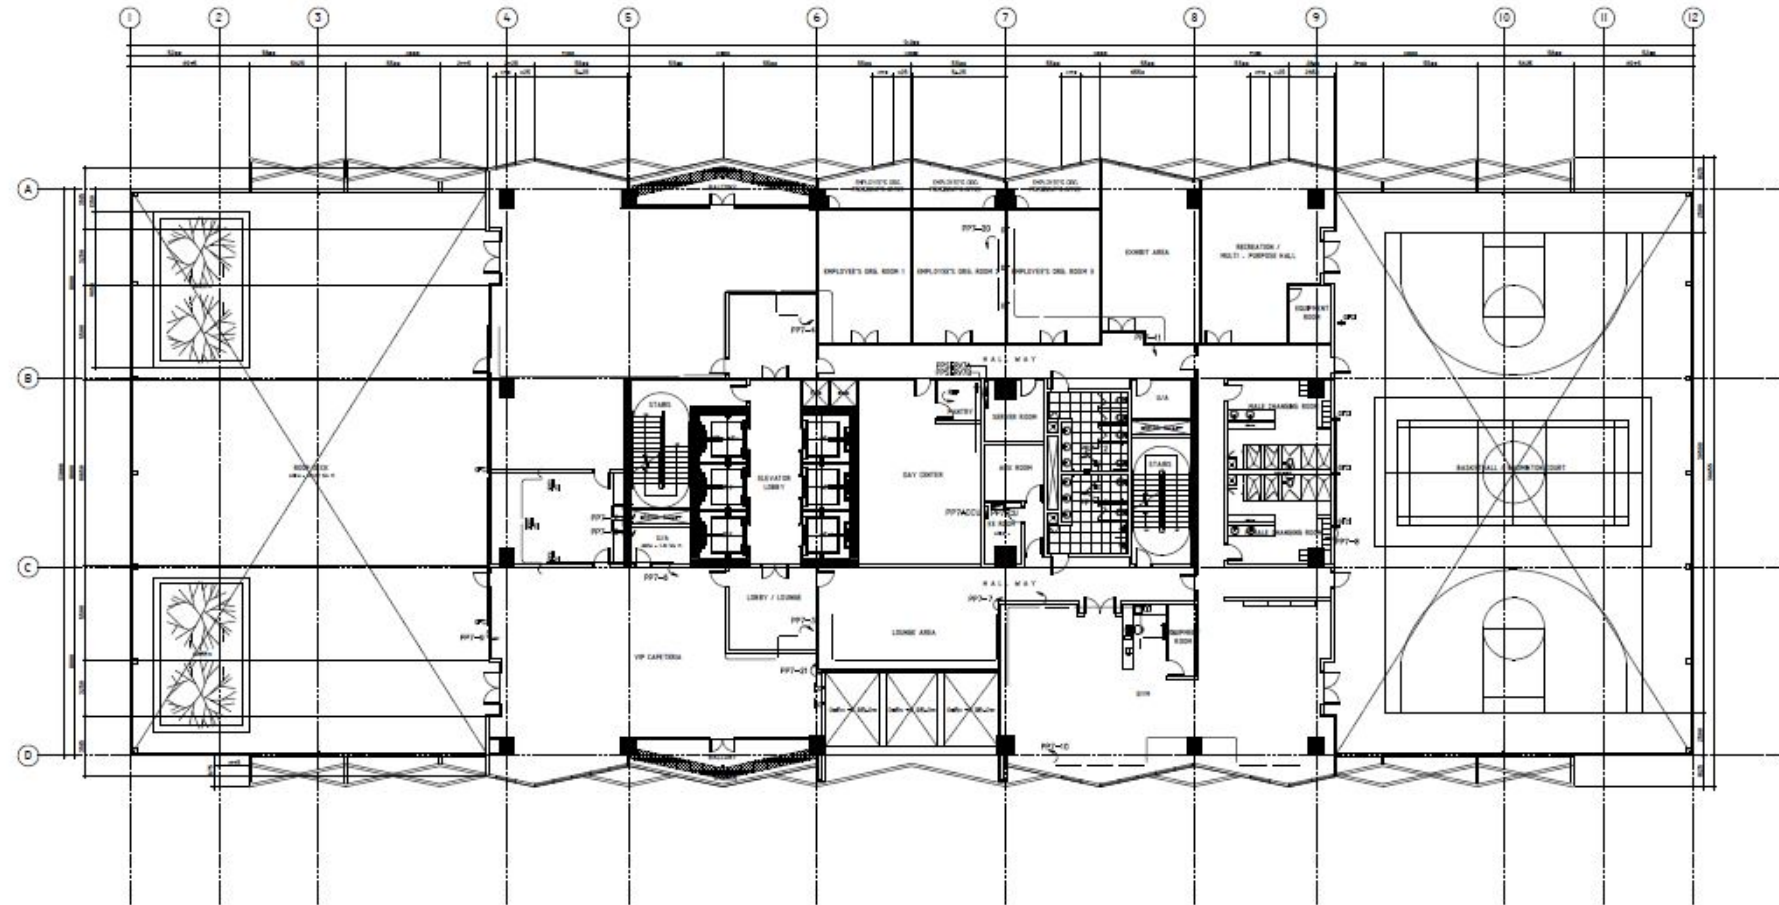


POWER LAYOUT

SCALE: 1:300 MTS

7th FLOOR




## ELECTRICAL PLANS

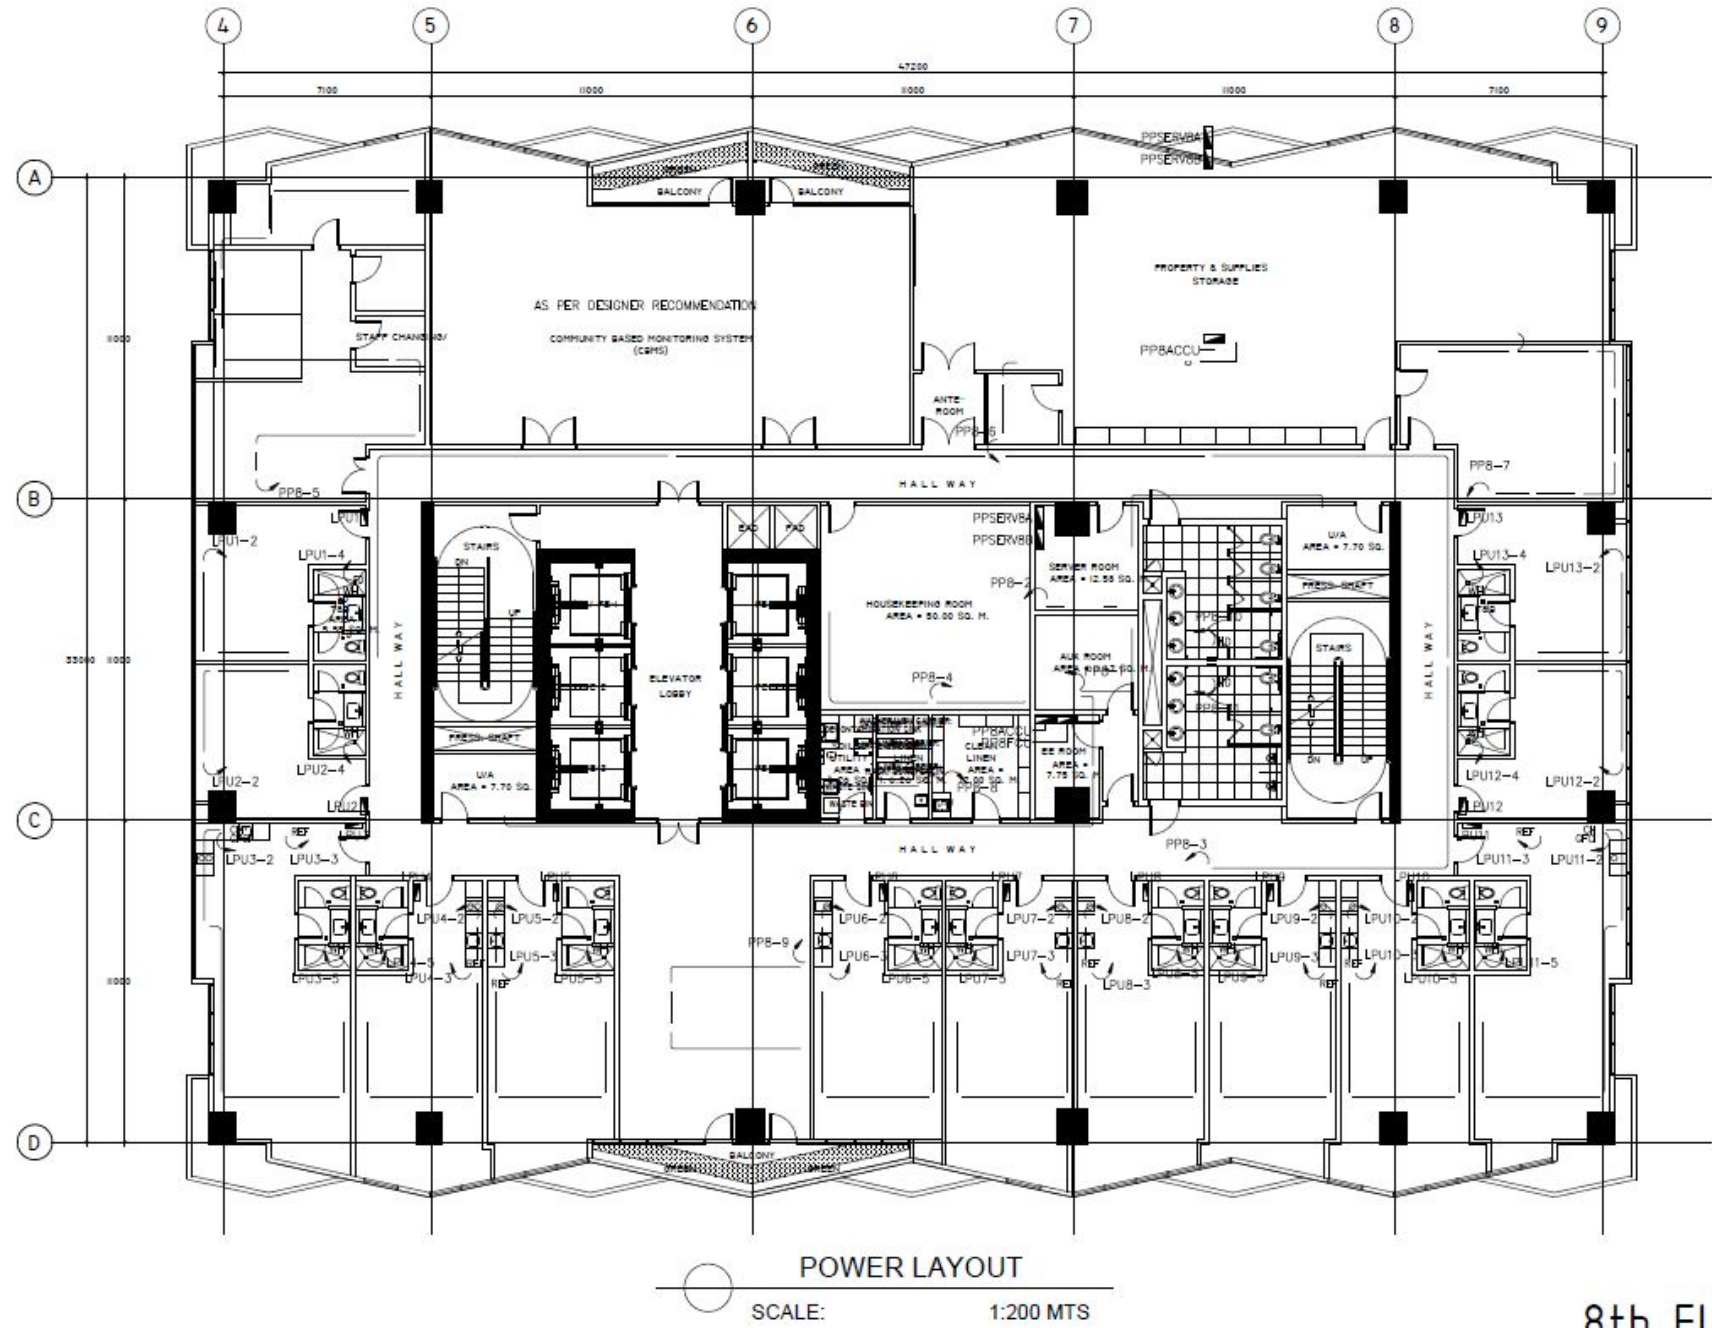

8th FL00R

## ELECTRICAL PLANS

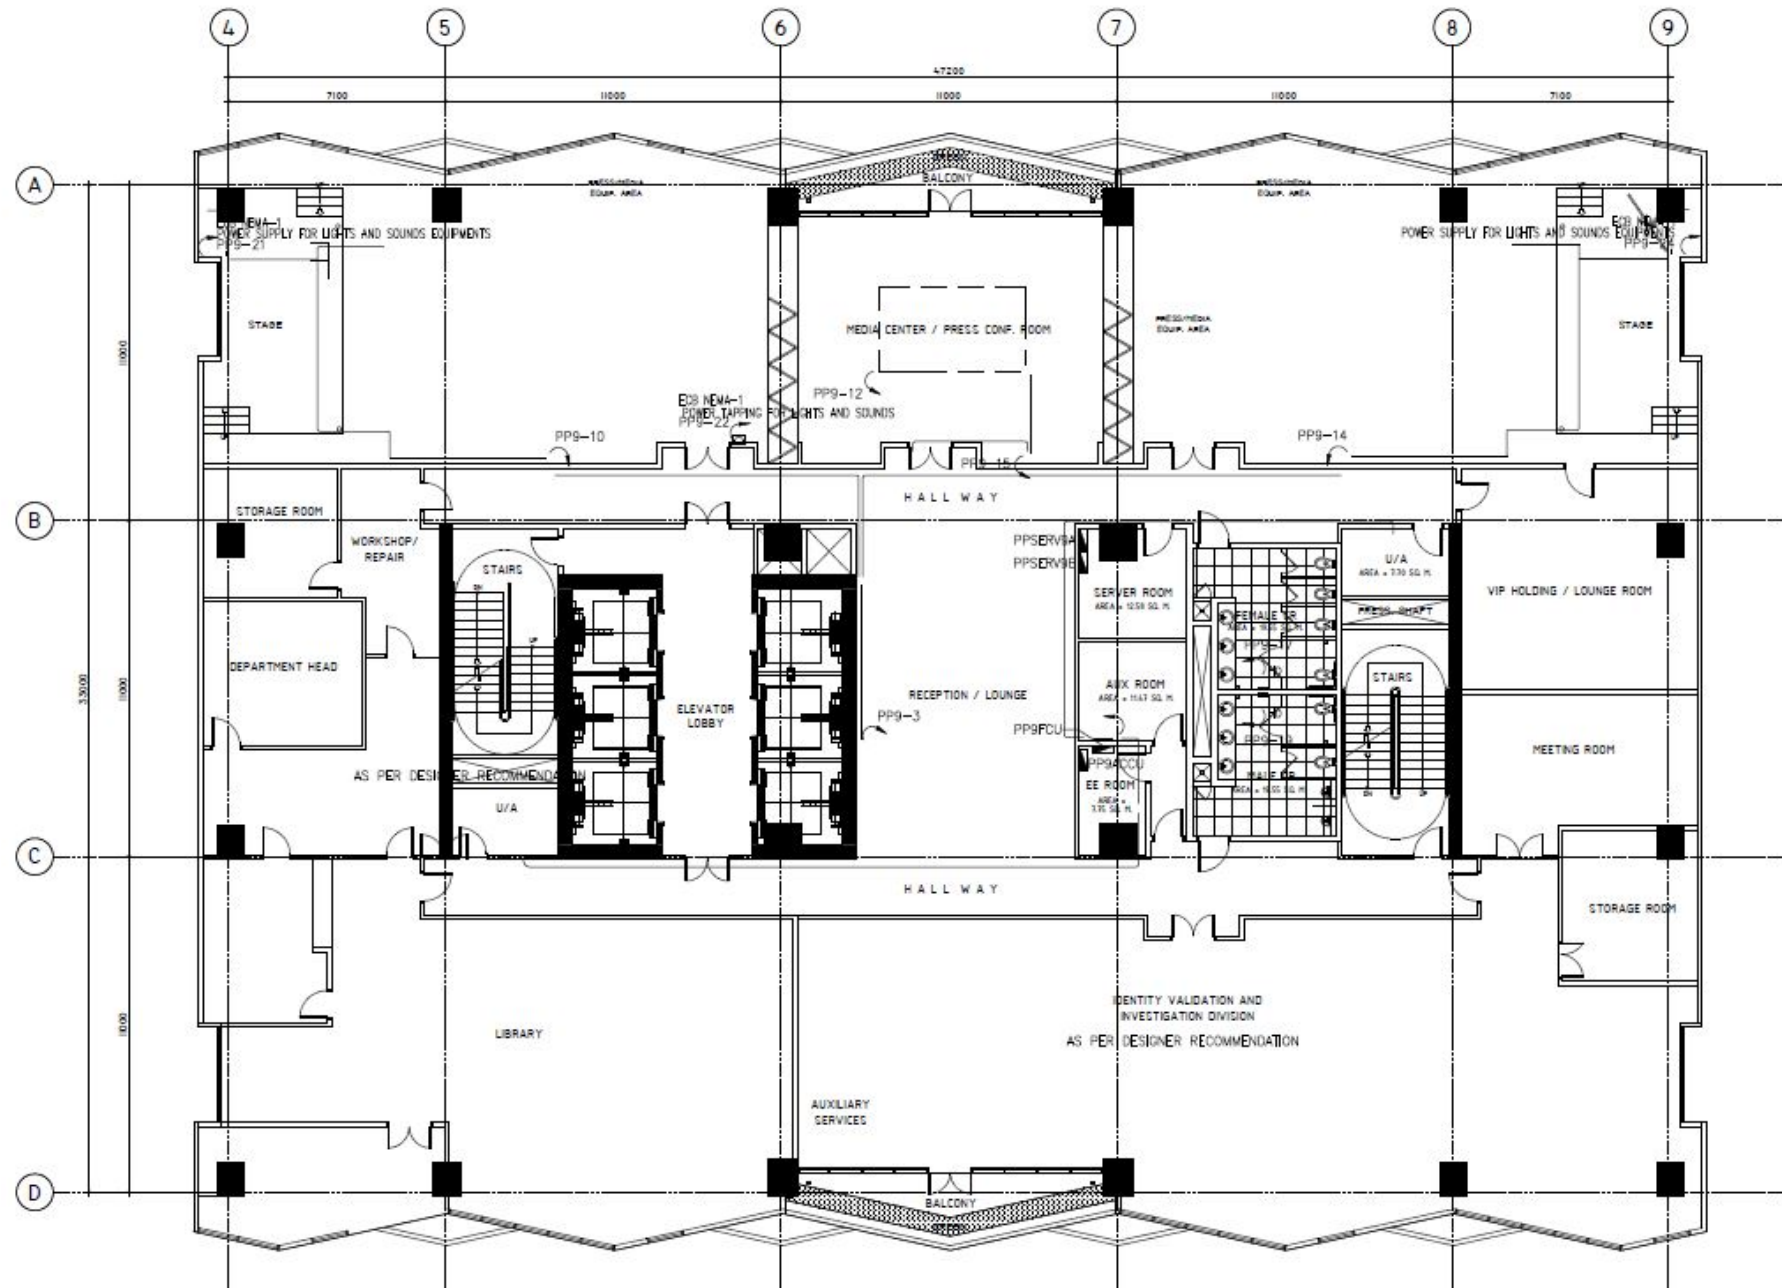


## POWER LAYOUT

SCALE:

1:200 MTS

9th FLOOR


ELECTRICAL PLANS

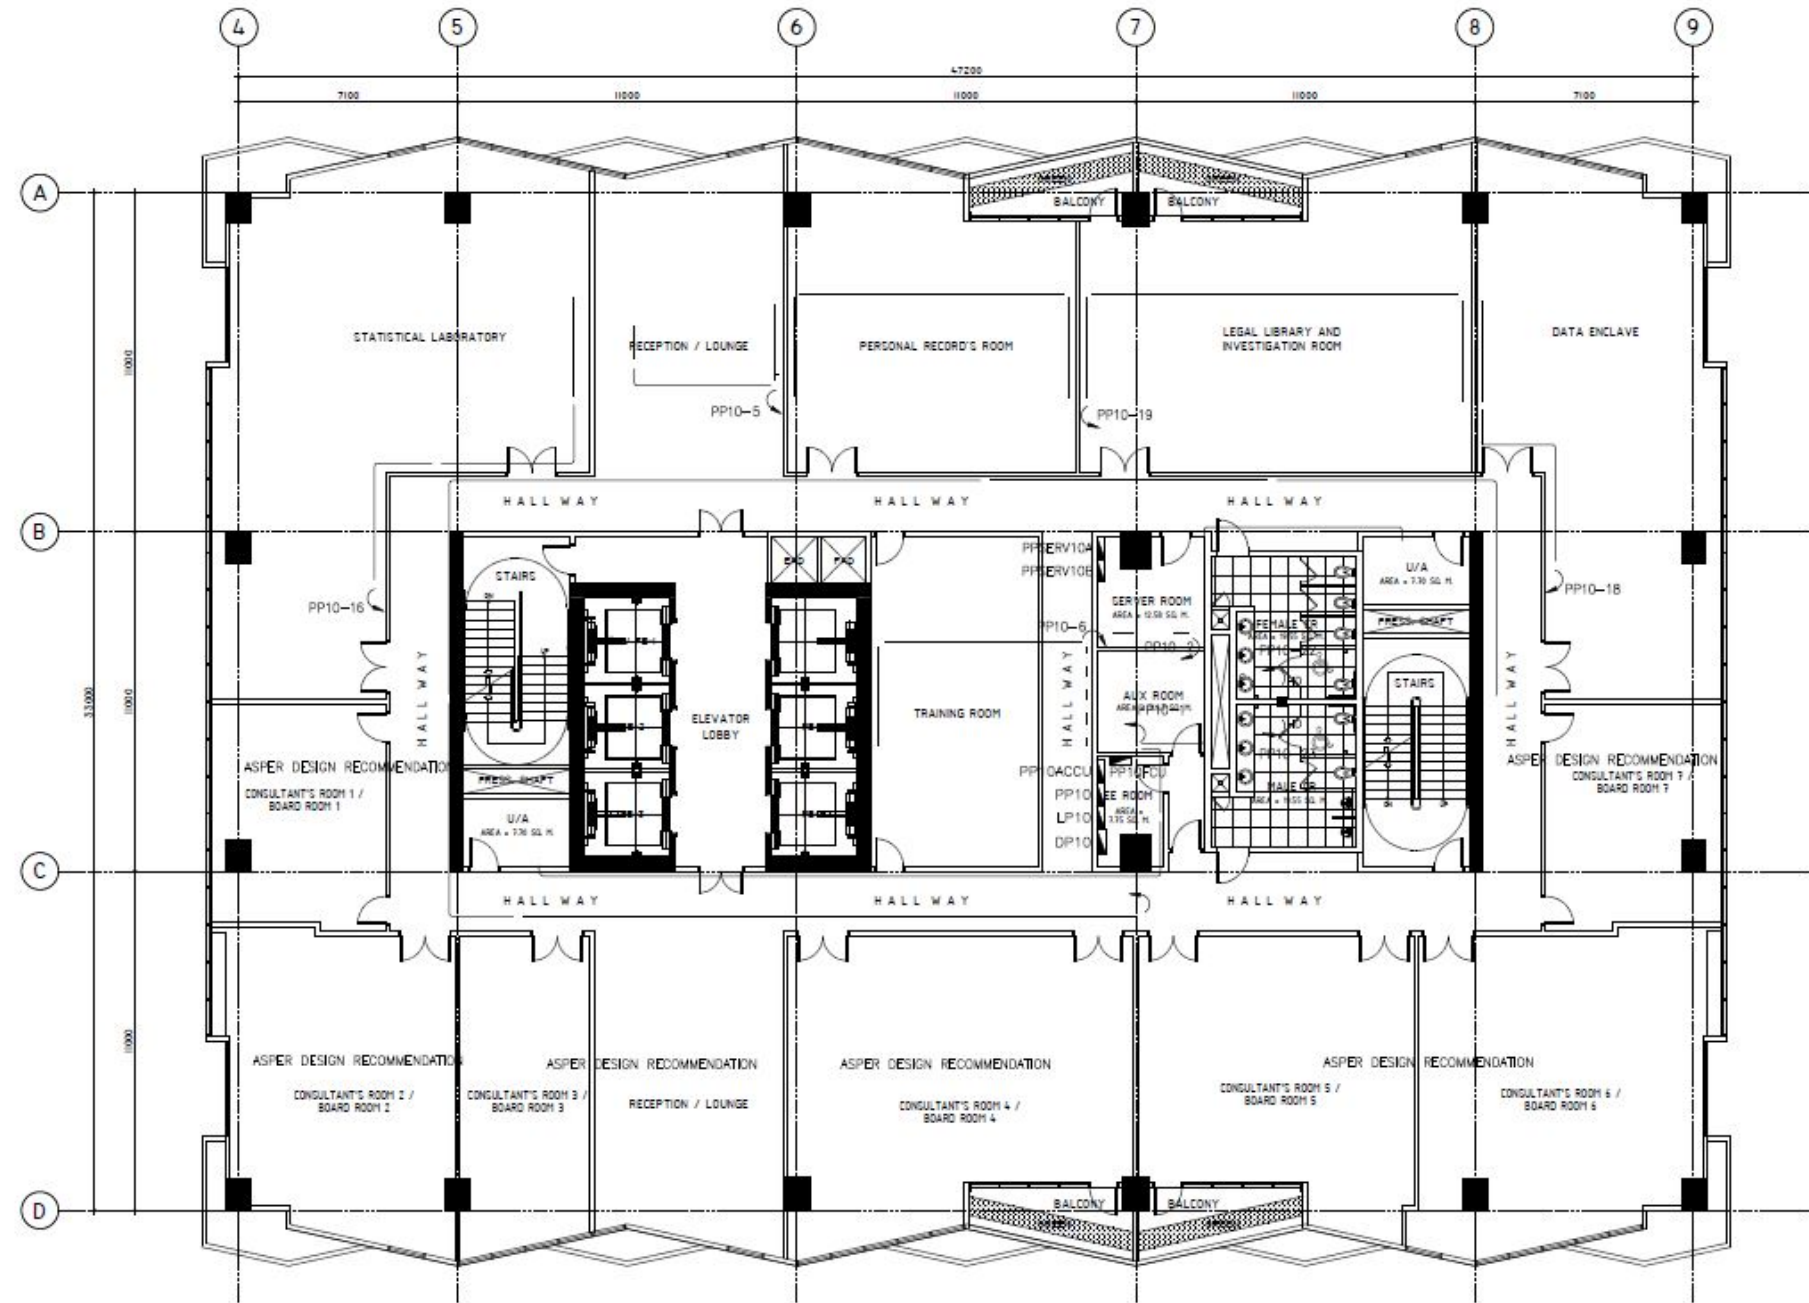

POWER LAYOUT  
SCALE: 1:200 MTS



ELECTRICAL PLANS

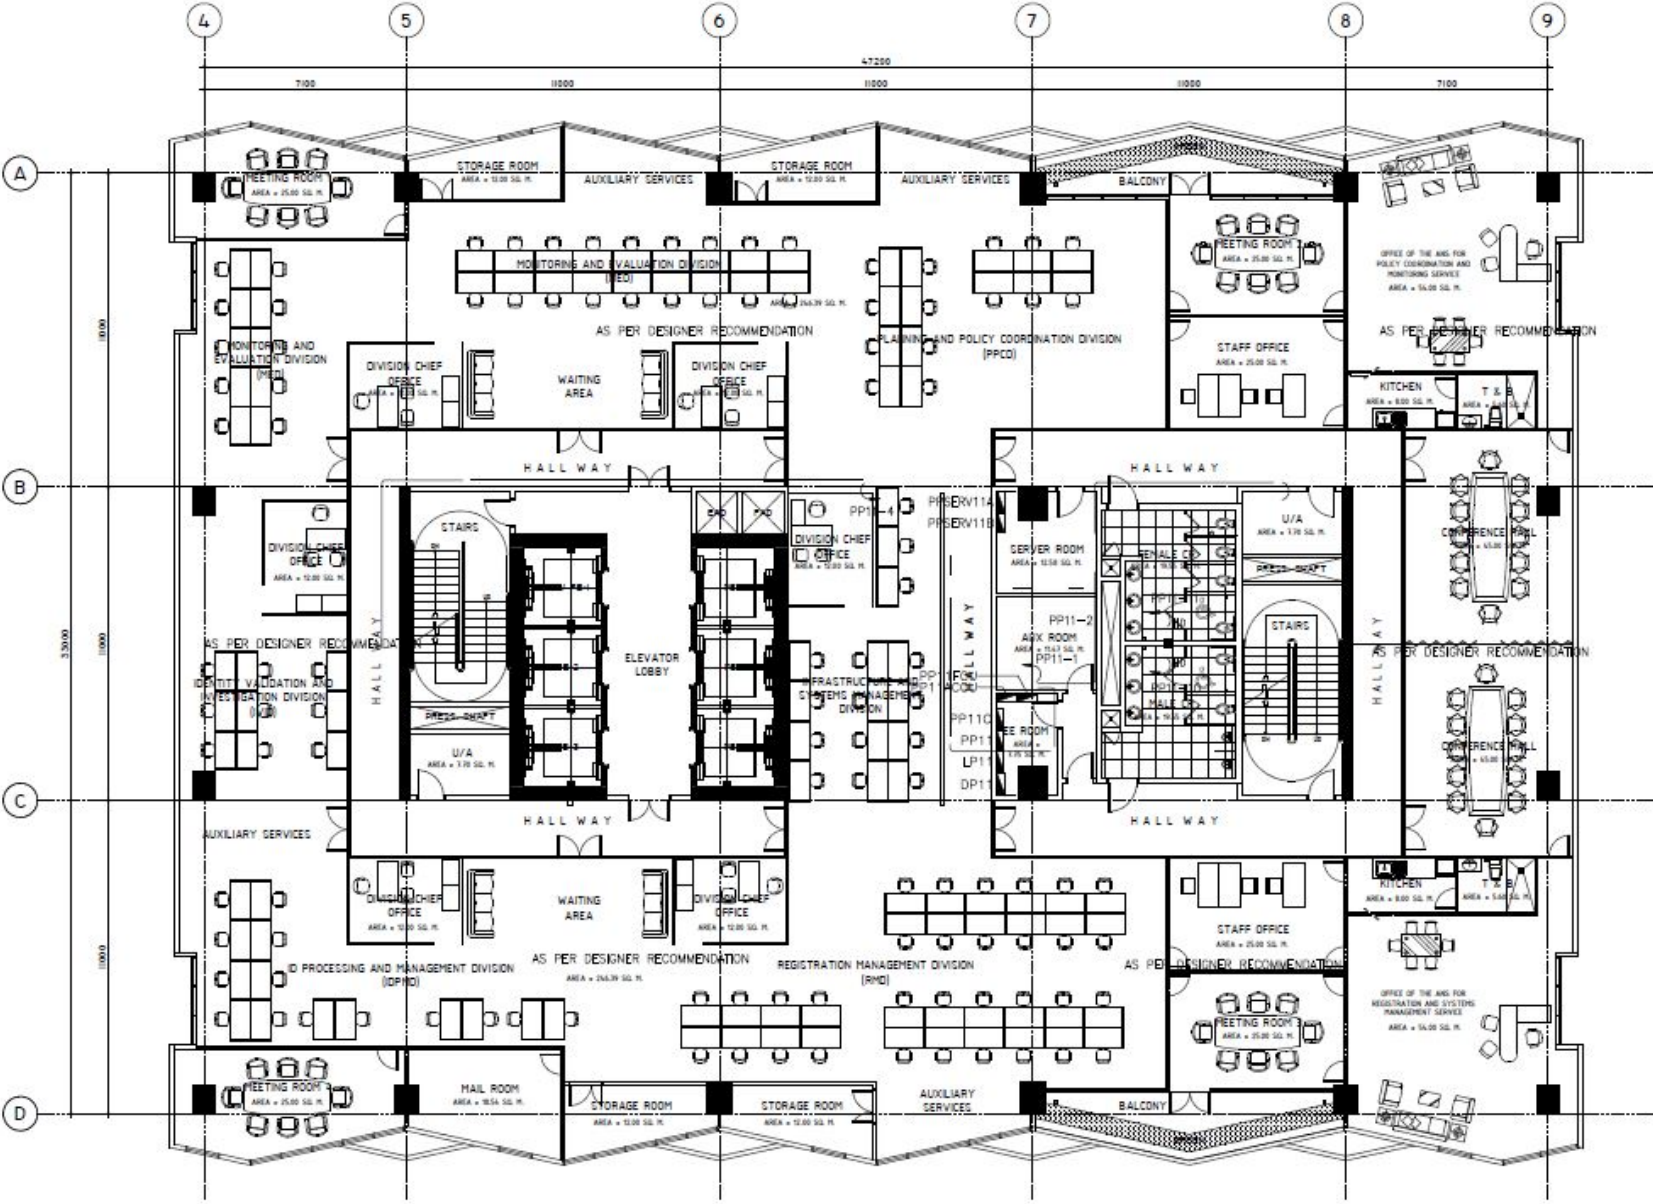


POWER LAYOUT  
SCALE: 1:200 MTS

PHILSYS REGISTRATION OFFICE

TOTAL FLOOR AREA = 1,557.60 sq.m.  
11th FLOOR



ELECTRICAL PLANS

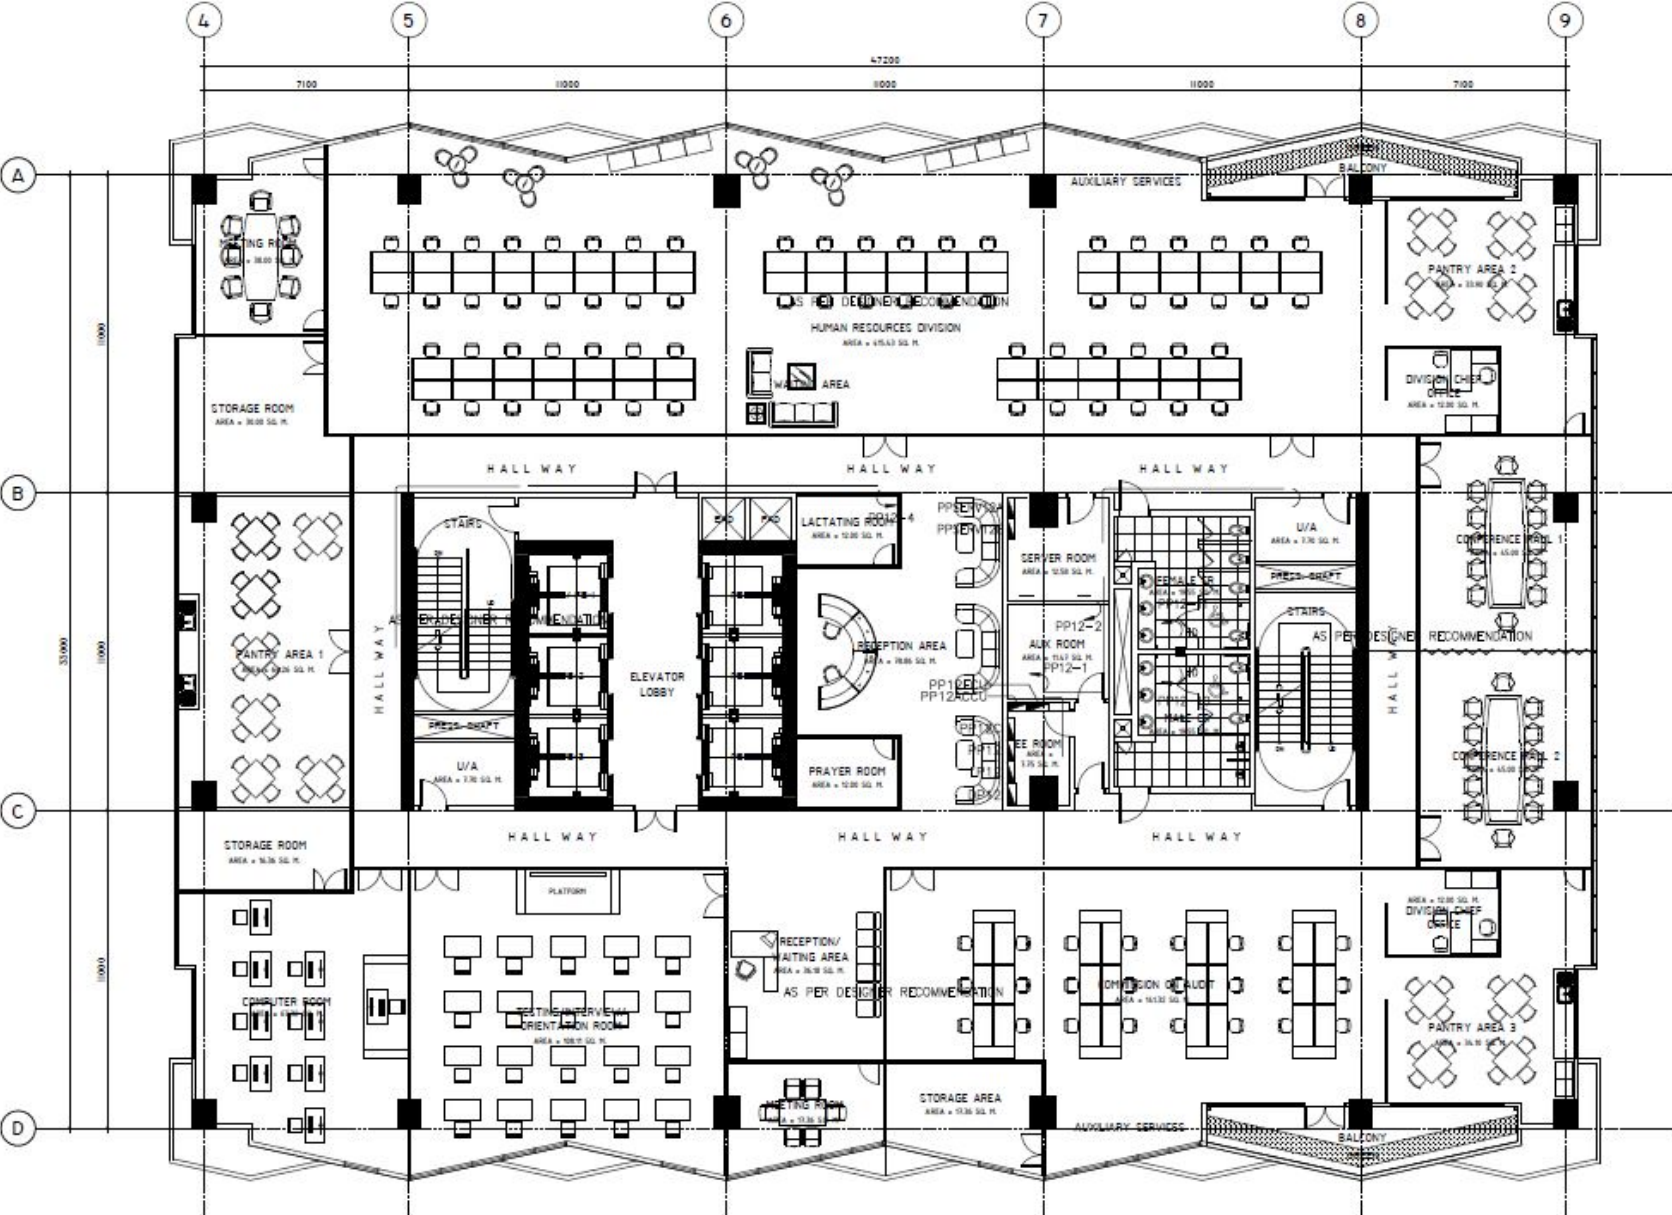


POWER LAYOUT  
SCALE: 1:200 MTS

HUMAN RESOURCES DIVISION &  
COMMISSION ON AUDIT

TOTAL FLOOR AREA = 1,557.60 sq.m.  
12th FLOOR

ELECTRICAL PLANS

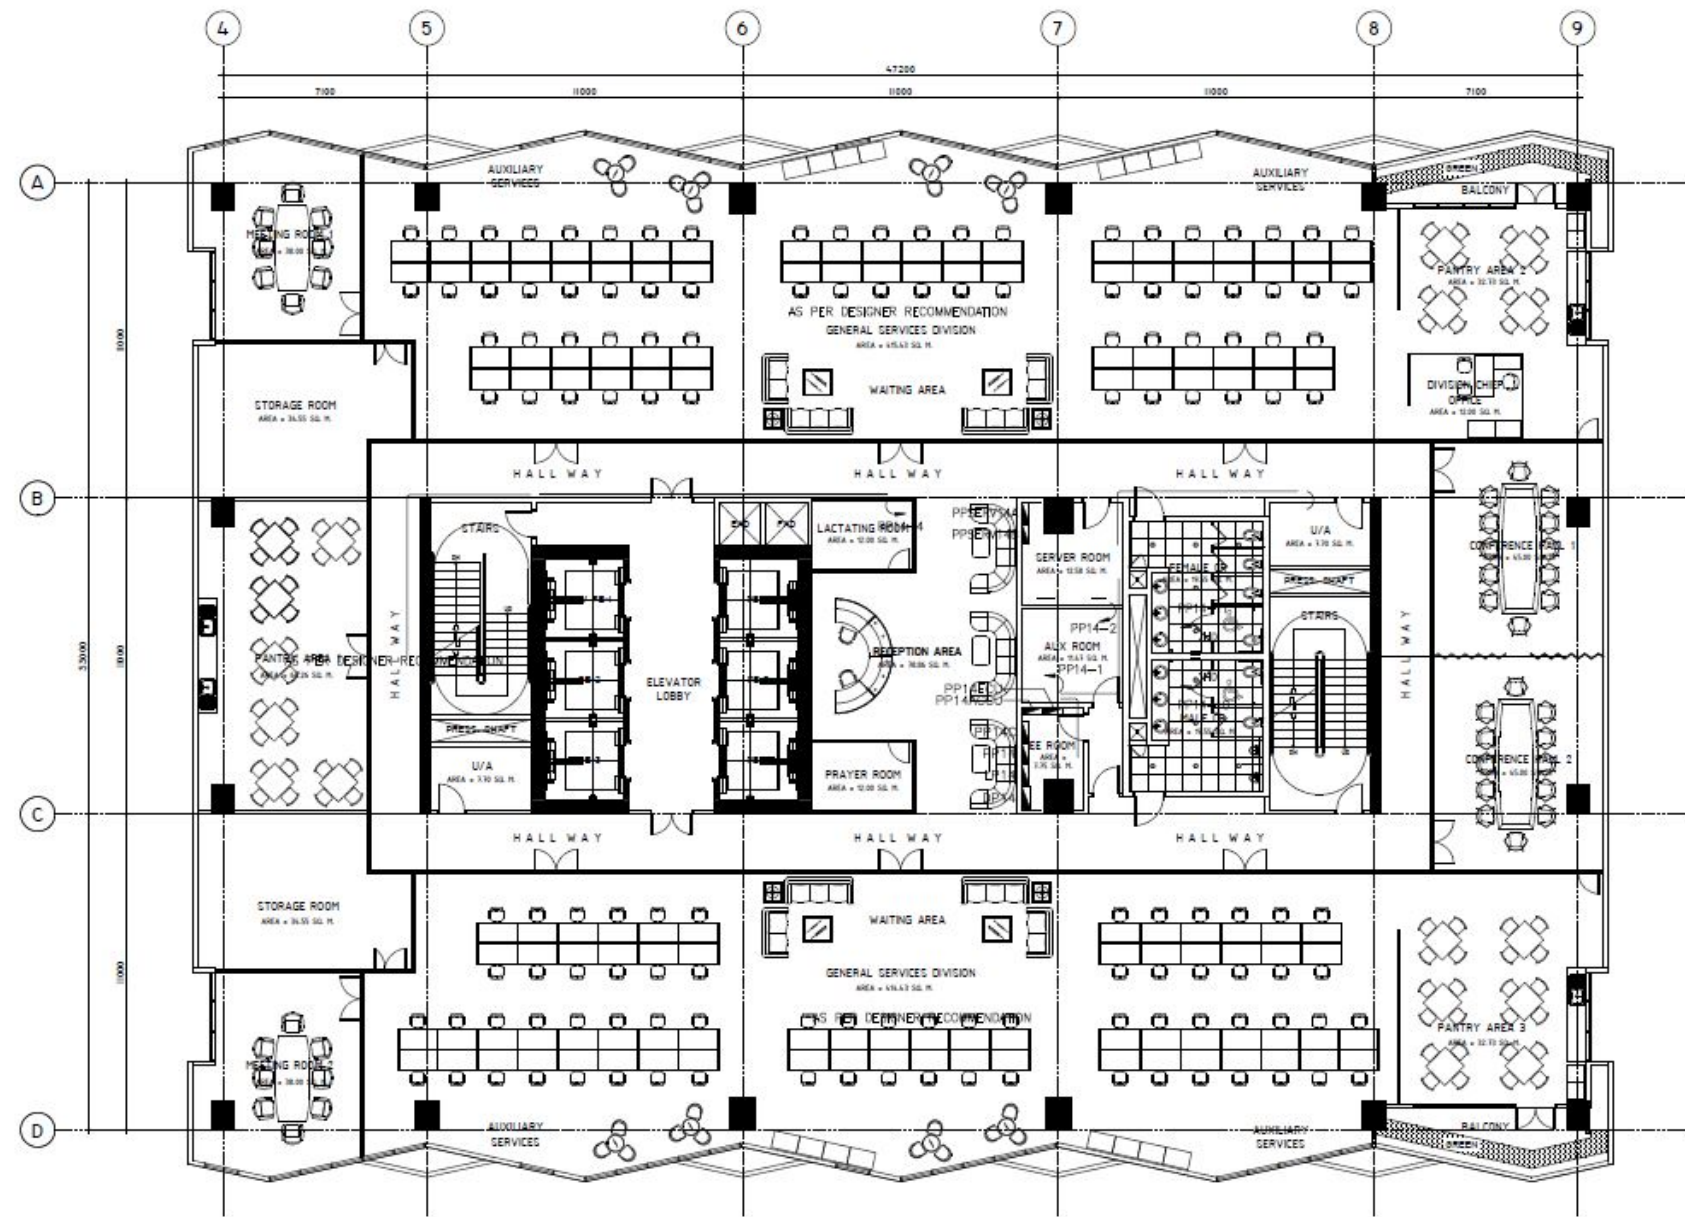


POWER LAYOUT  
SCALE: 1:200 MTS

GENERAL SERVICES DIVISION


TOTAL FLOOR AREA = 1,557.60 sq.m.  
14th FLOOR



ELECTRICAL PLANS

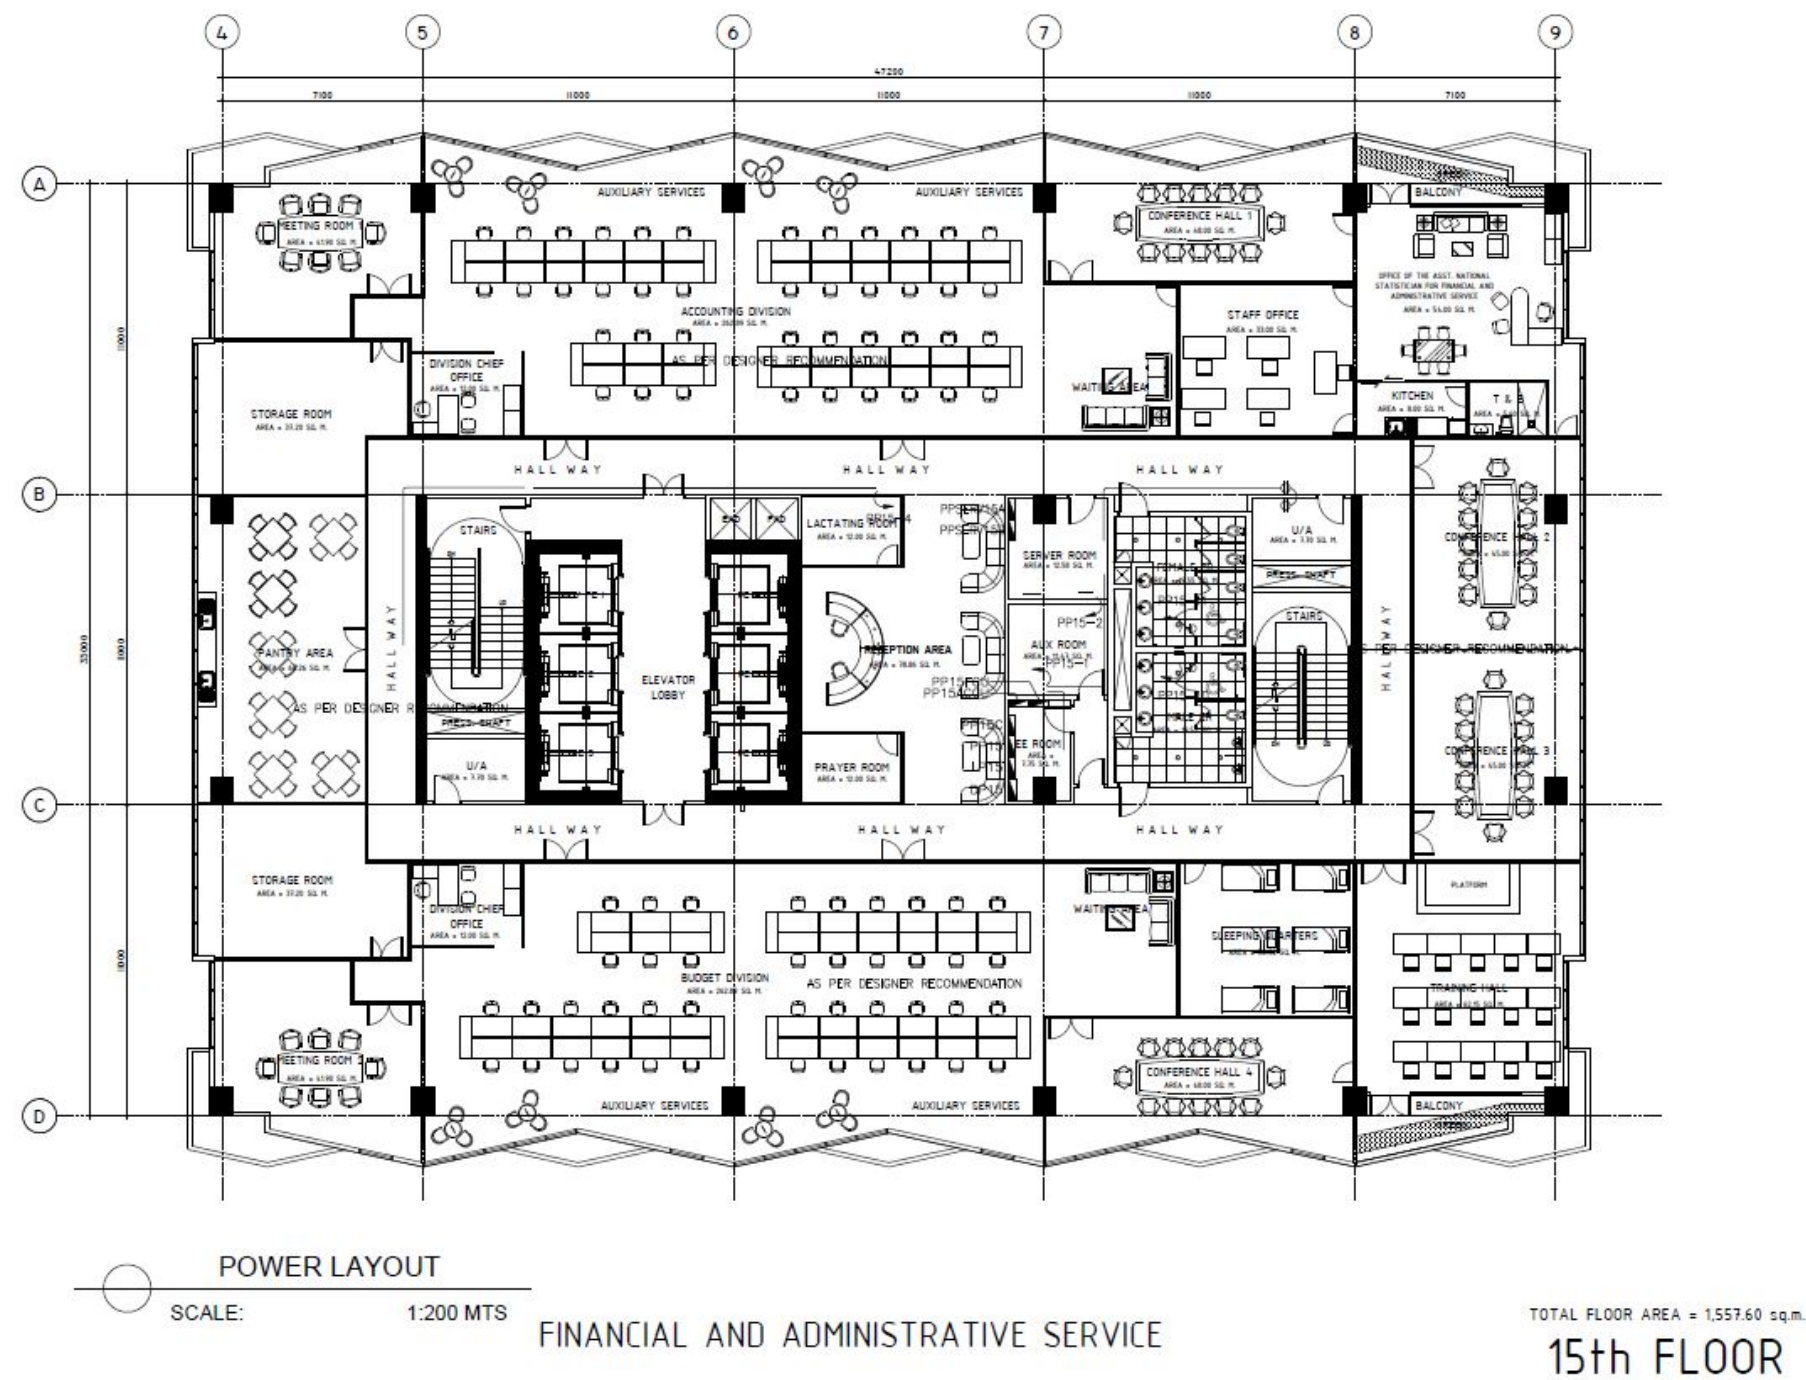

## ELECTRICAL PLANS

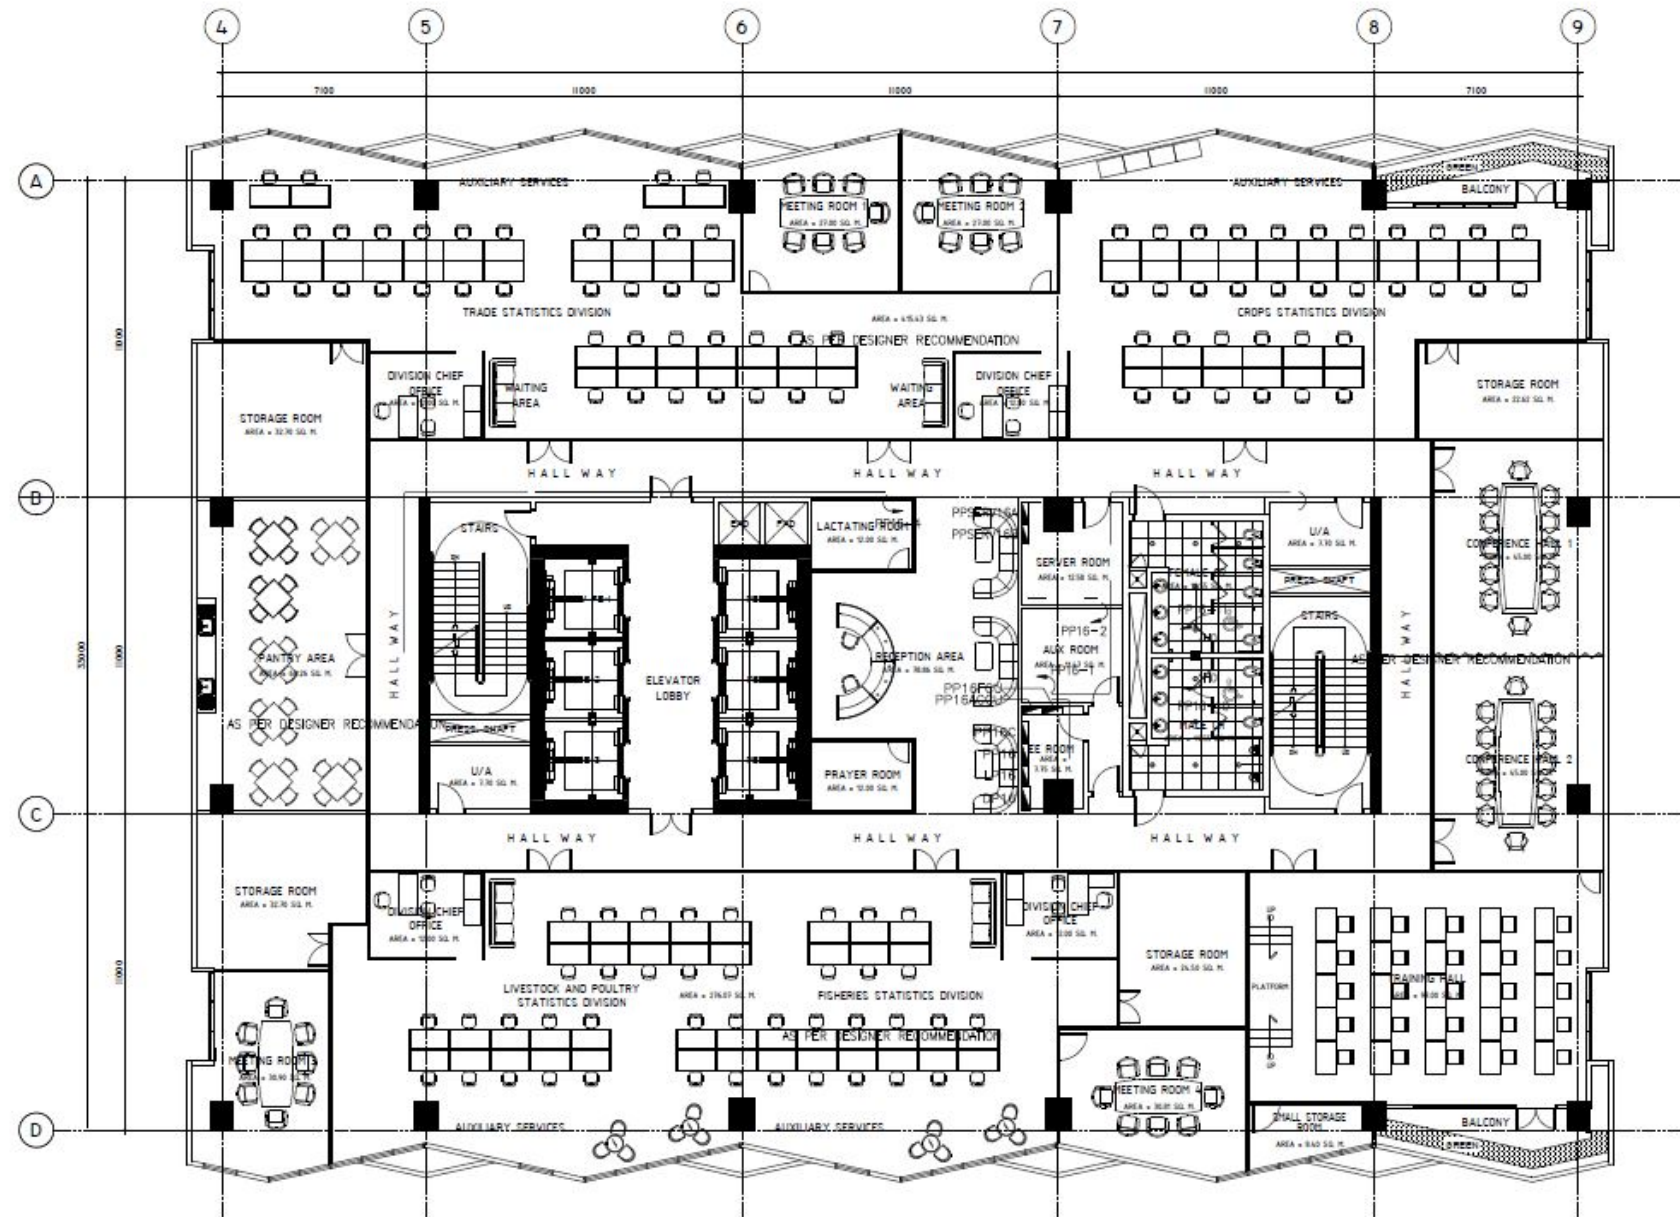

## POWER LAYOUT

SCALE:

1:200 MTS


ECONOMIC SECTOR STATISTICS SERVICE

TOTAL FLOOR AREA = 1,557.60 sq.m.

16th FLOOR



ELECTRICAL PLANS

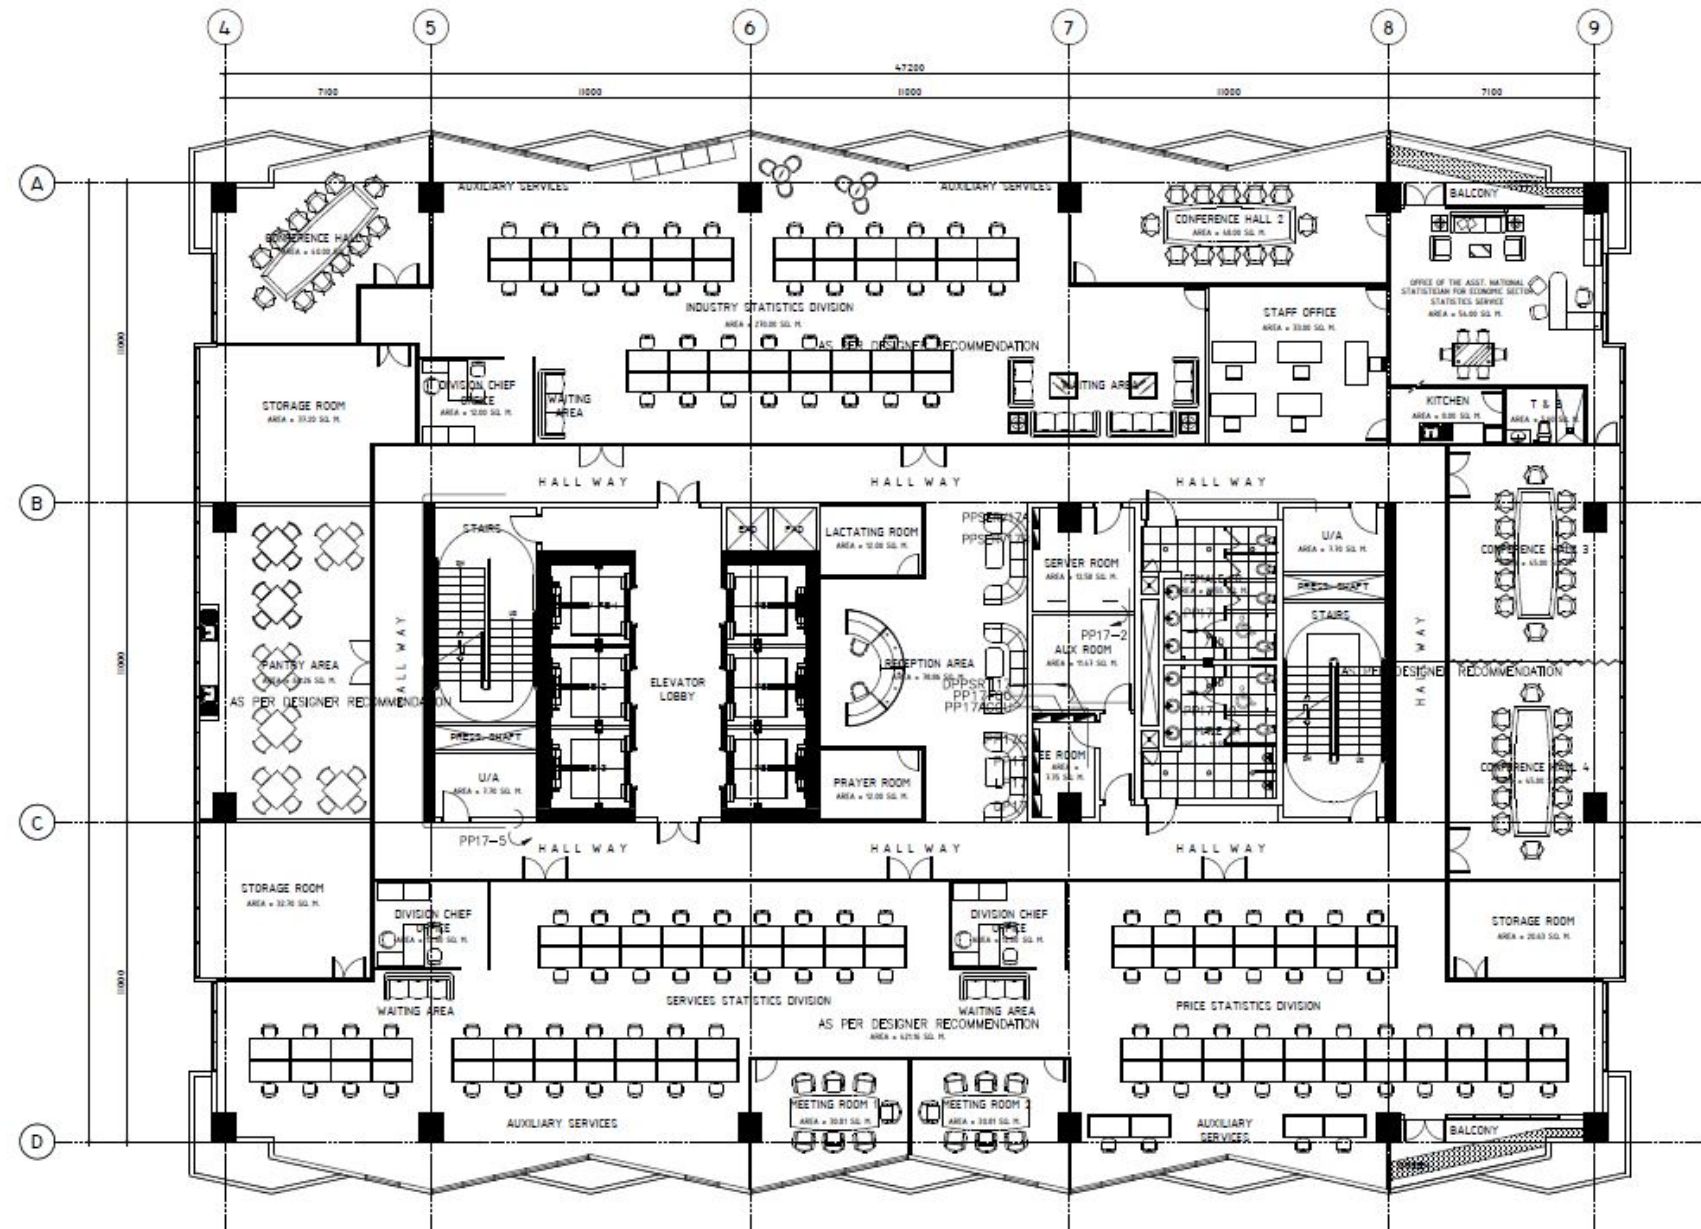

POWER LAYOUT  
SCALE: 1:200 MTS

ECONOMIC SECTOR STATISTICS SERVICE

TOTAL FLOOR AREA = 1,557.60 sq.m.  
17th FLOOR