


ELECTRICAL PLANS

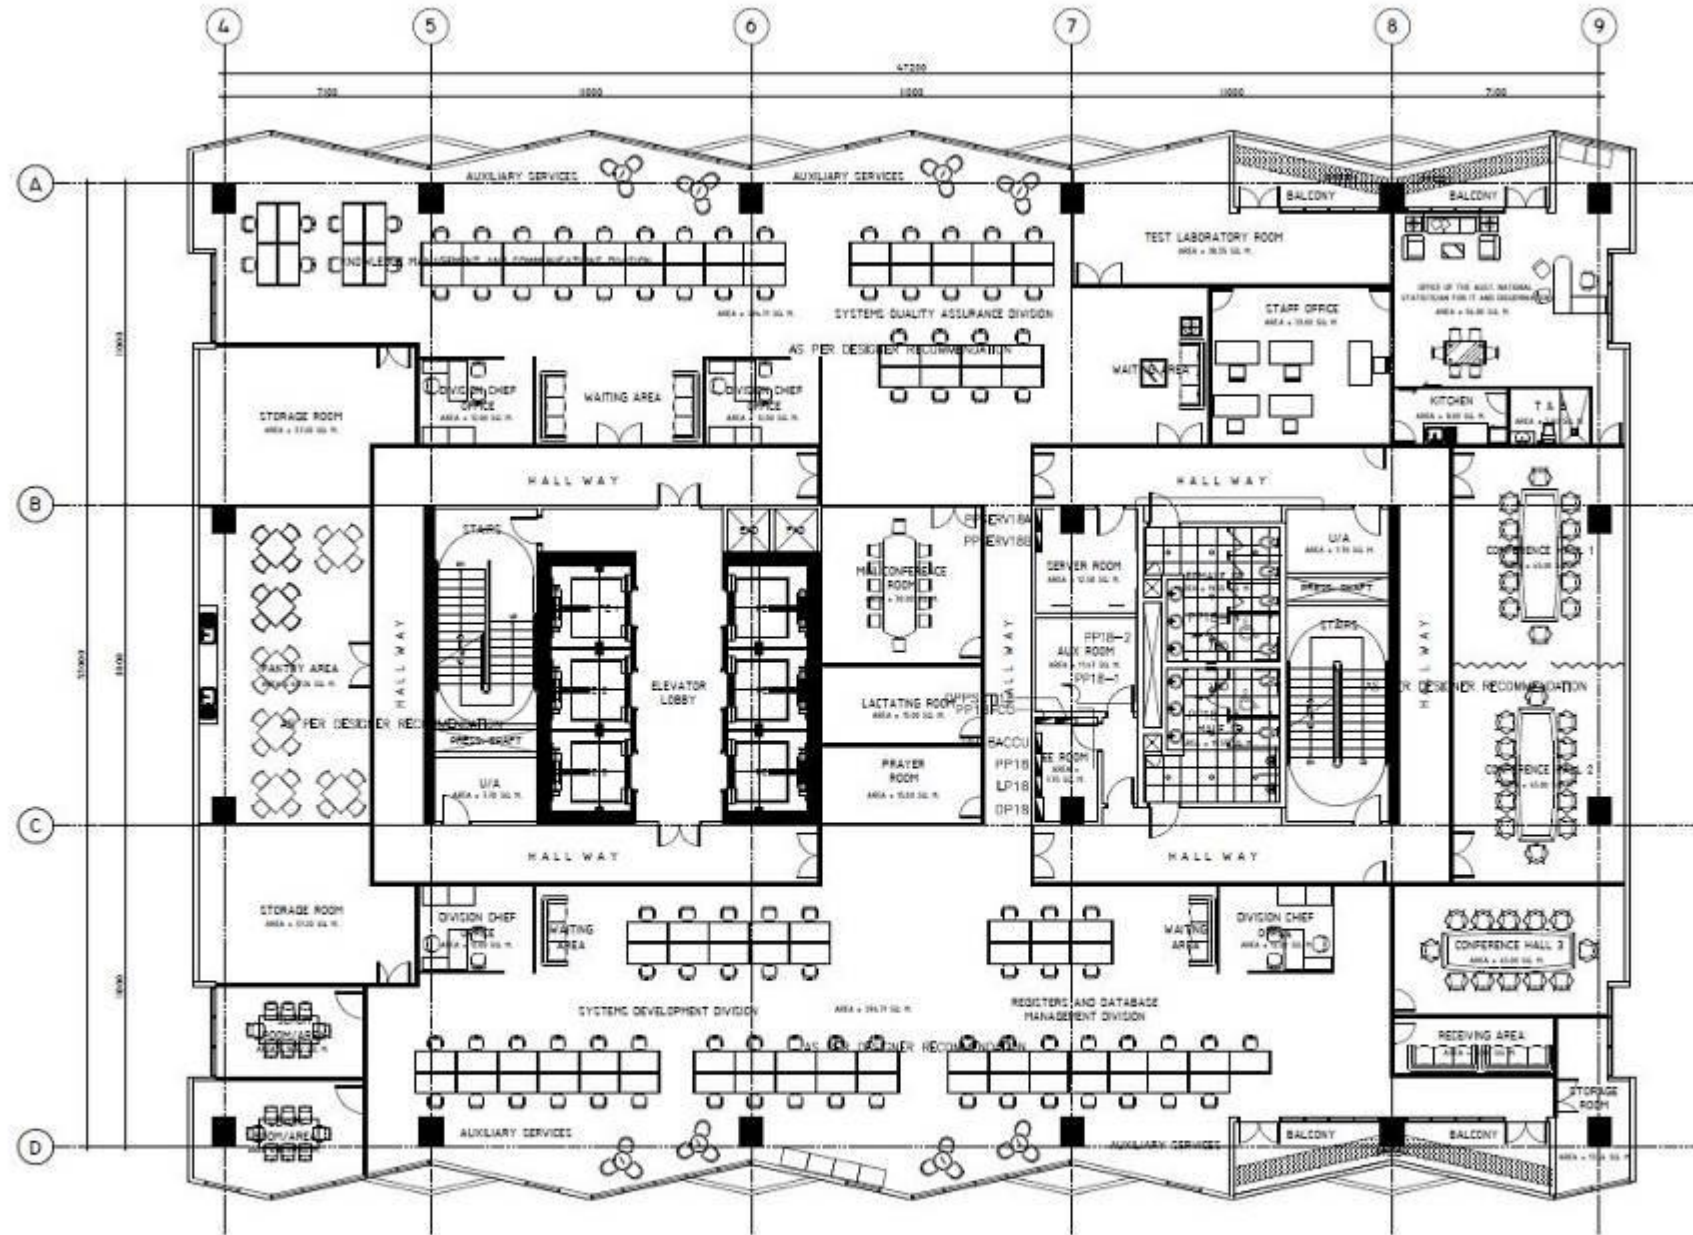


POWER LAYOUT
SCALE: 1:200 MTS

I.T. AND DISSEMINATION SERVICE

TOTAL FLOOR AREA = 1557.60 sq.m.
18th FLOOR

ELECTRICAL PLANS

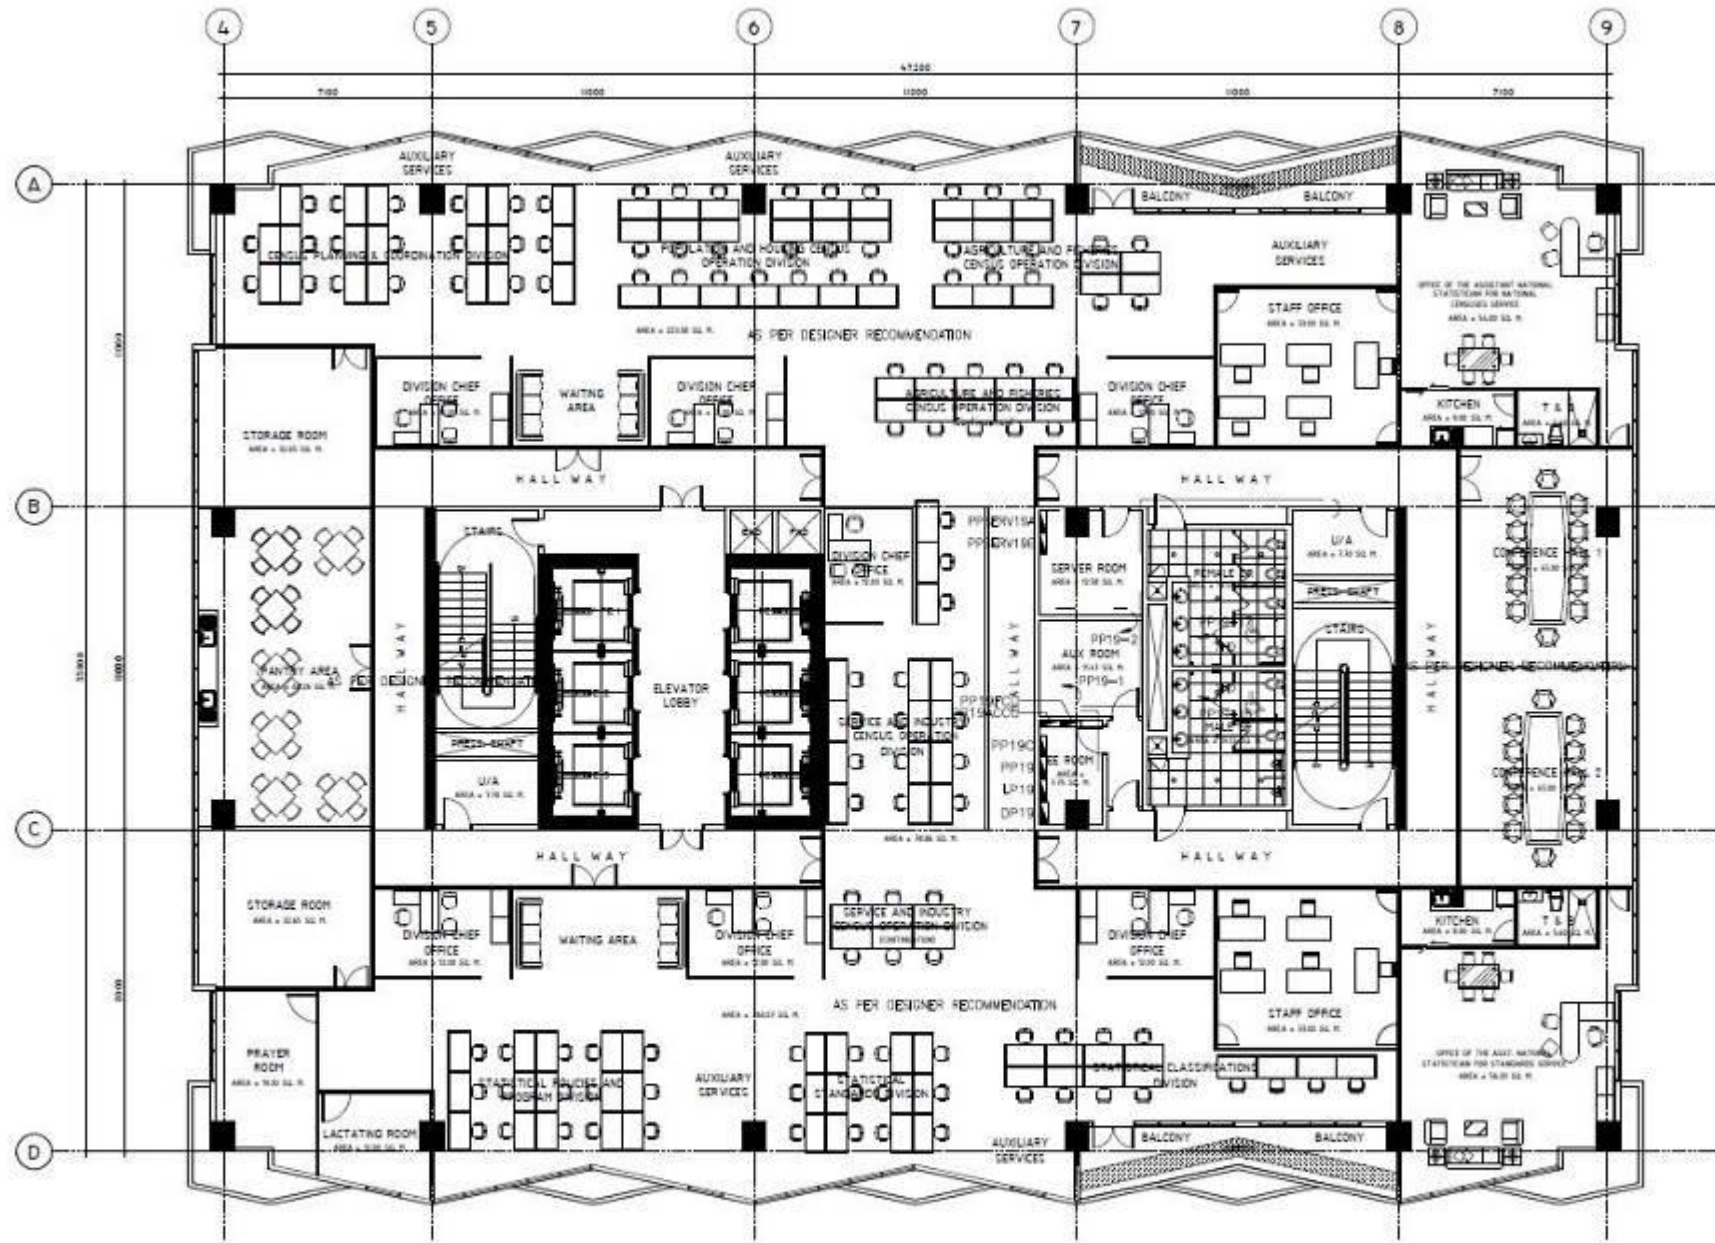


POWER LAYOUT
 SCALE: 1:200 MTS

NATIONAL CENSUSES SERVICE &
 STANDARDS SERVICE

TOTAL FLOOR AREA = 1,557.60 sq.m.
 19th FLOOR

ELECTRICAL PLANS

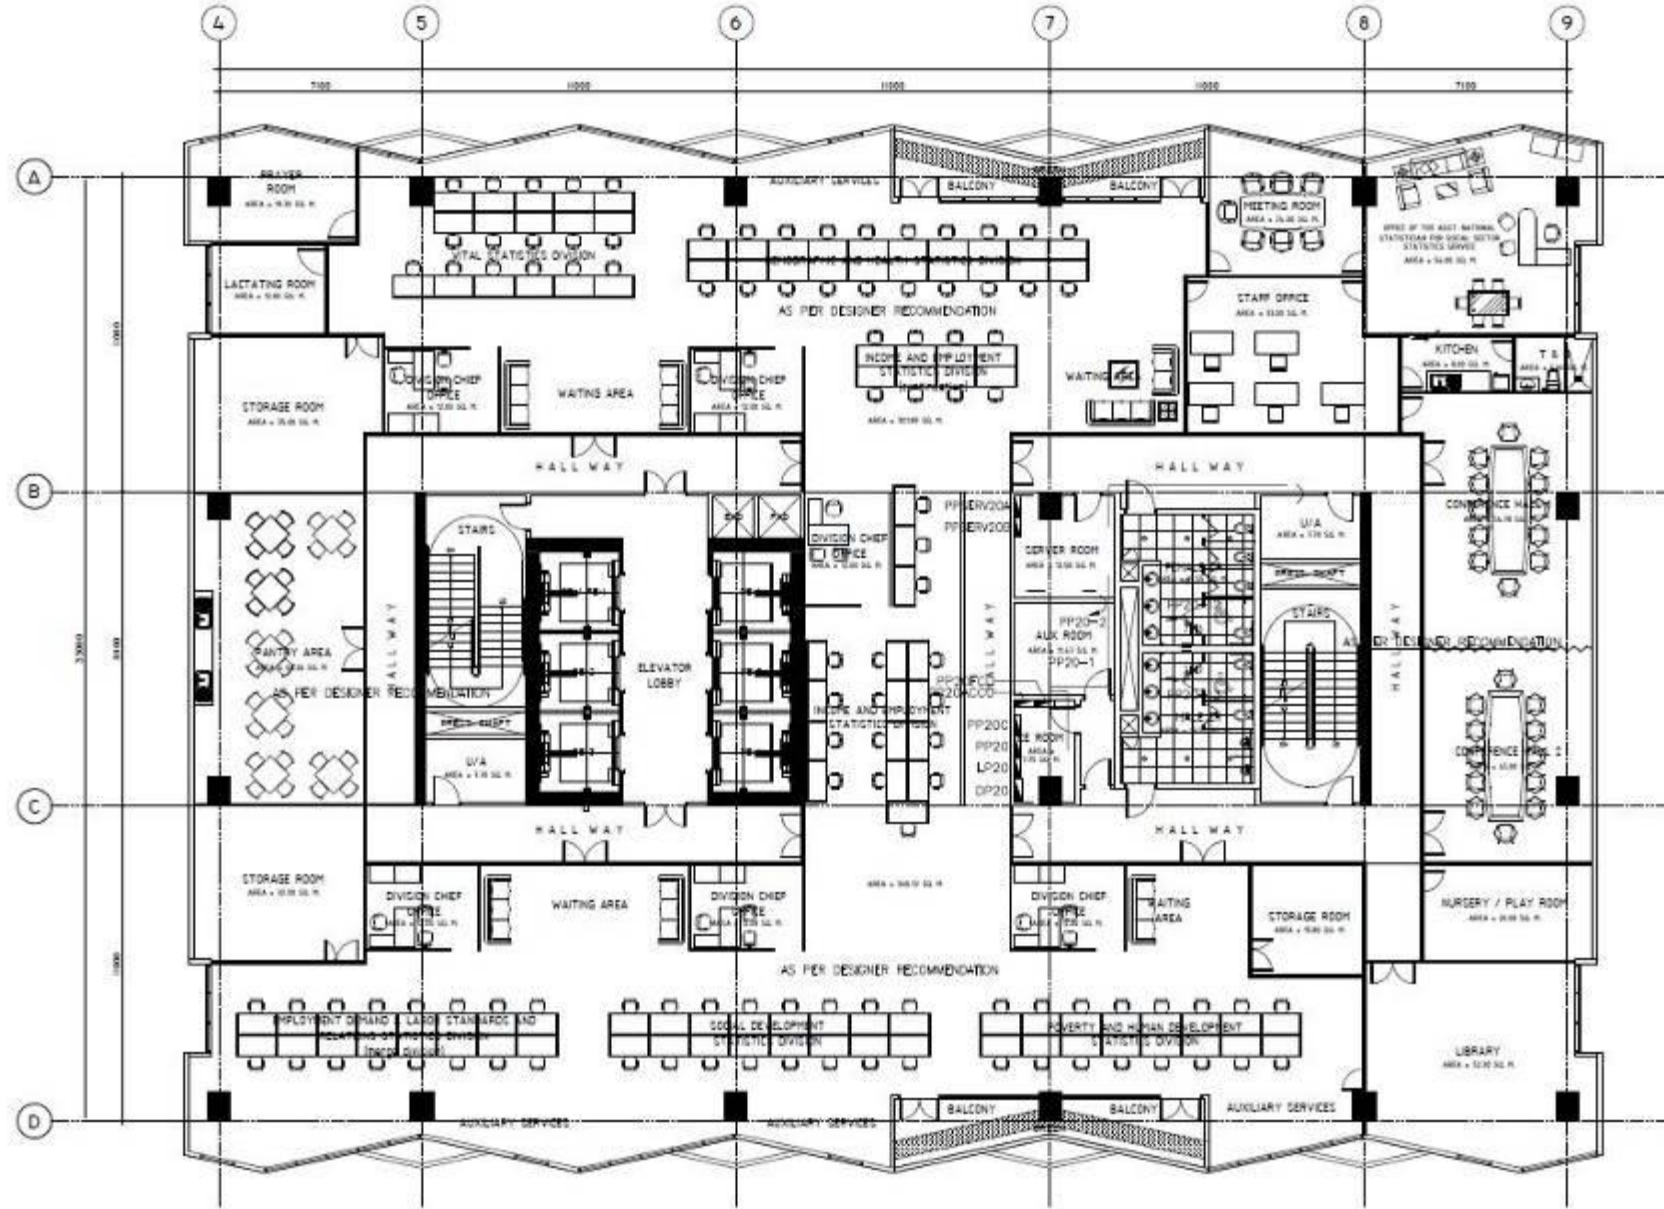


POWER LAYOUT
SCALE: 1:200 MTS

SOCIAL SECTOR STATISTICS SERVICE

TOTAL FLOOR AREA = 1,557.60 sq.m.
20th FLOOR

ELECTRICAL PLANS

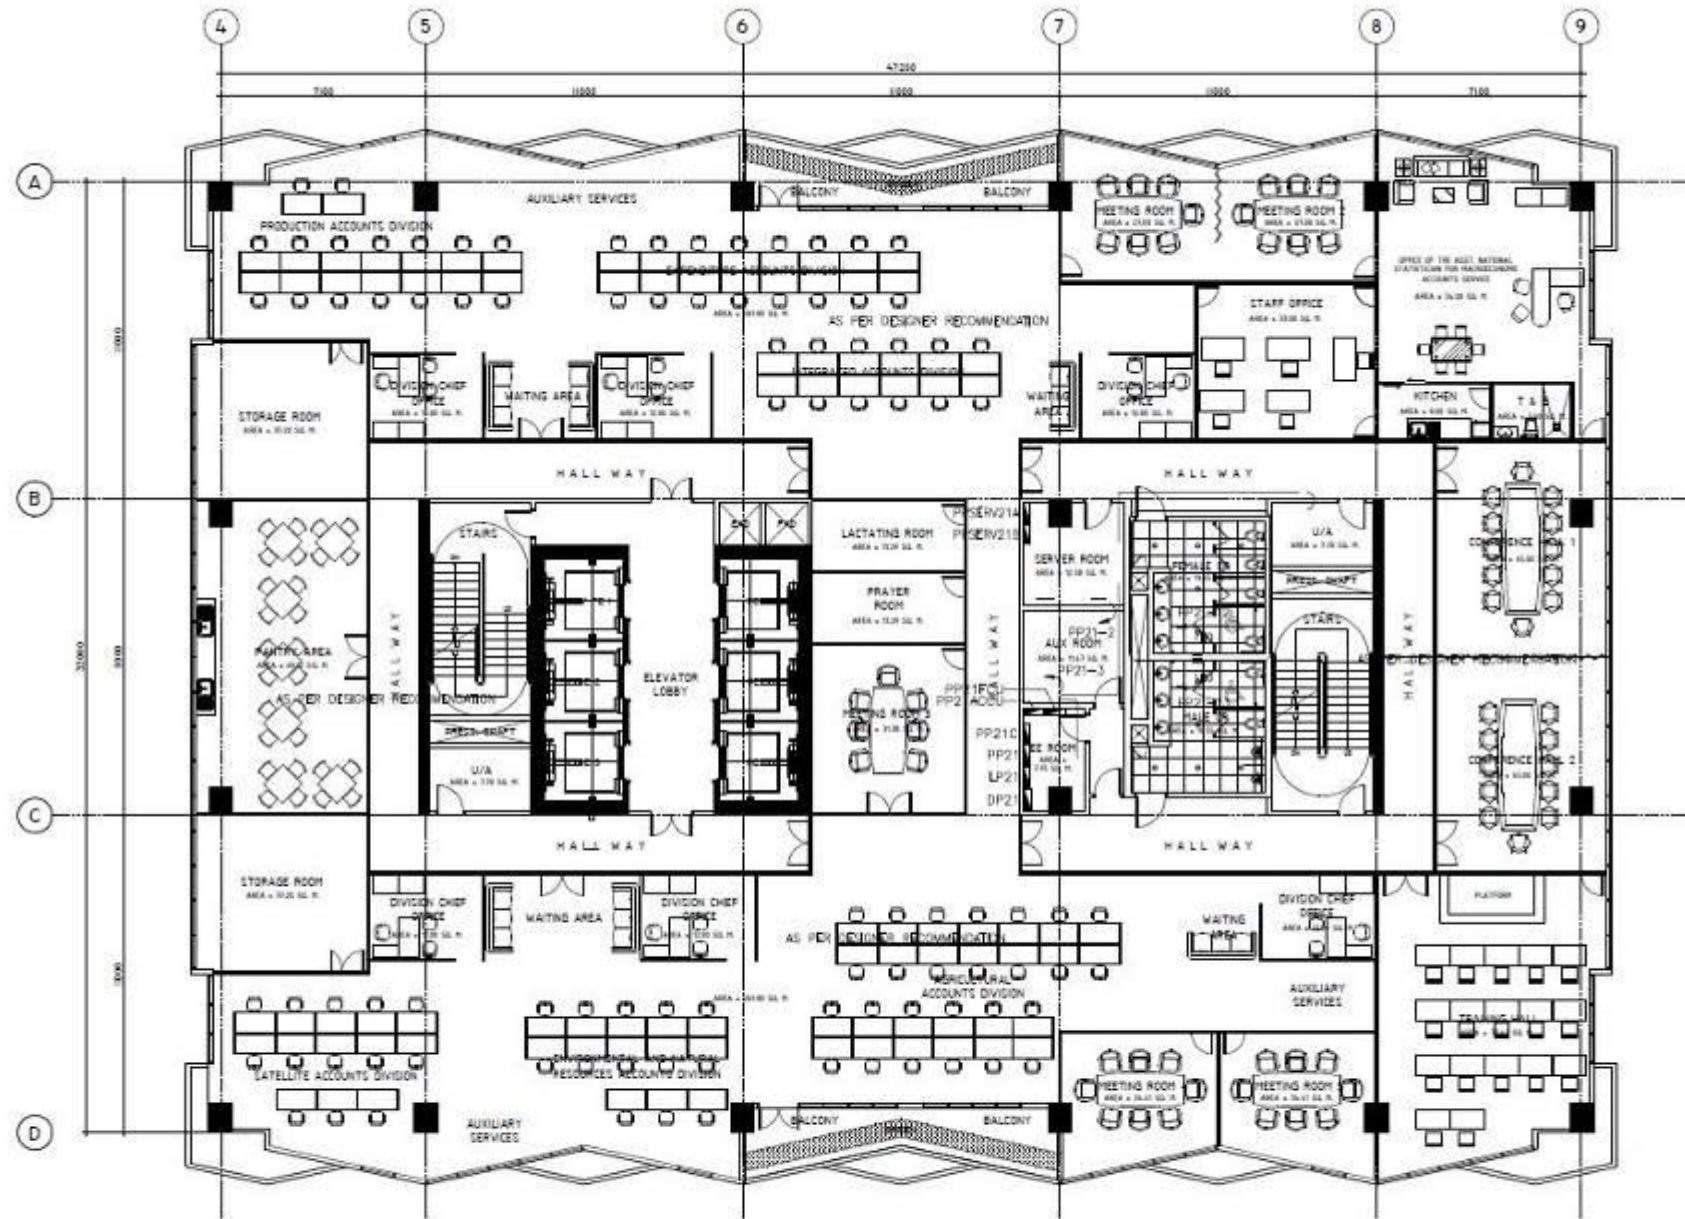


POWER LAYOUT
SCALE: 1:200 MTS

MACROECONOMIC ACCOUNTS SERVICE

TOTAL FLOOR AREA = 1,557.60 sq.m.

21st FLOOR

ELECTRICAL PLANS

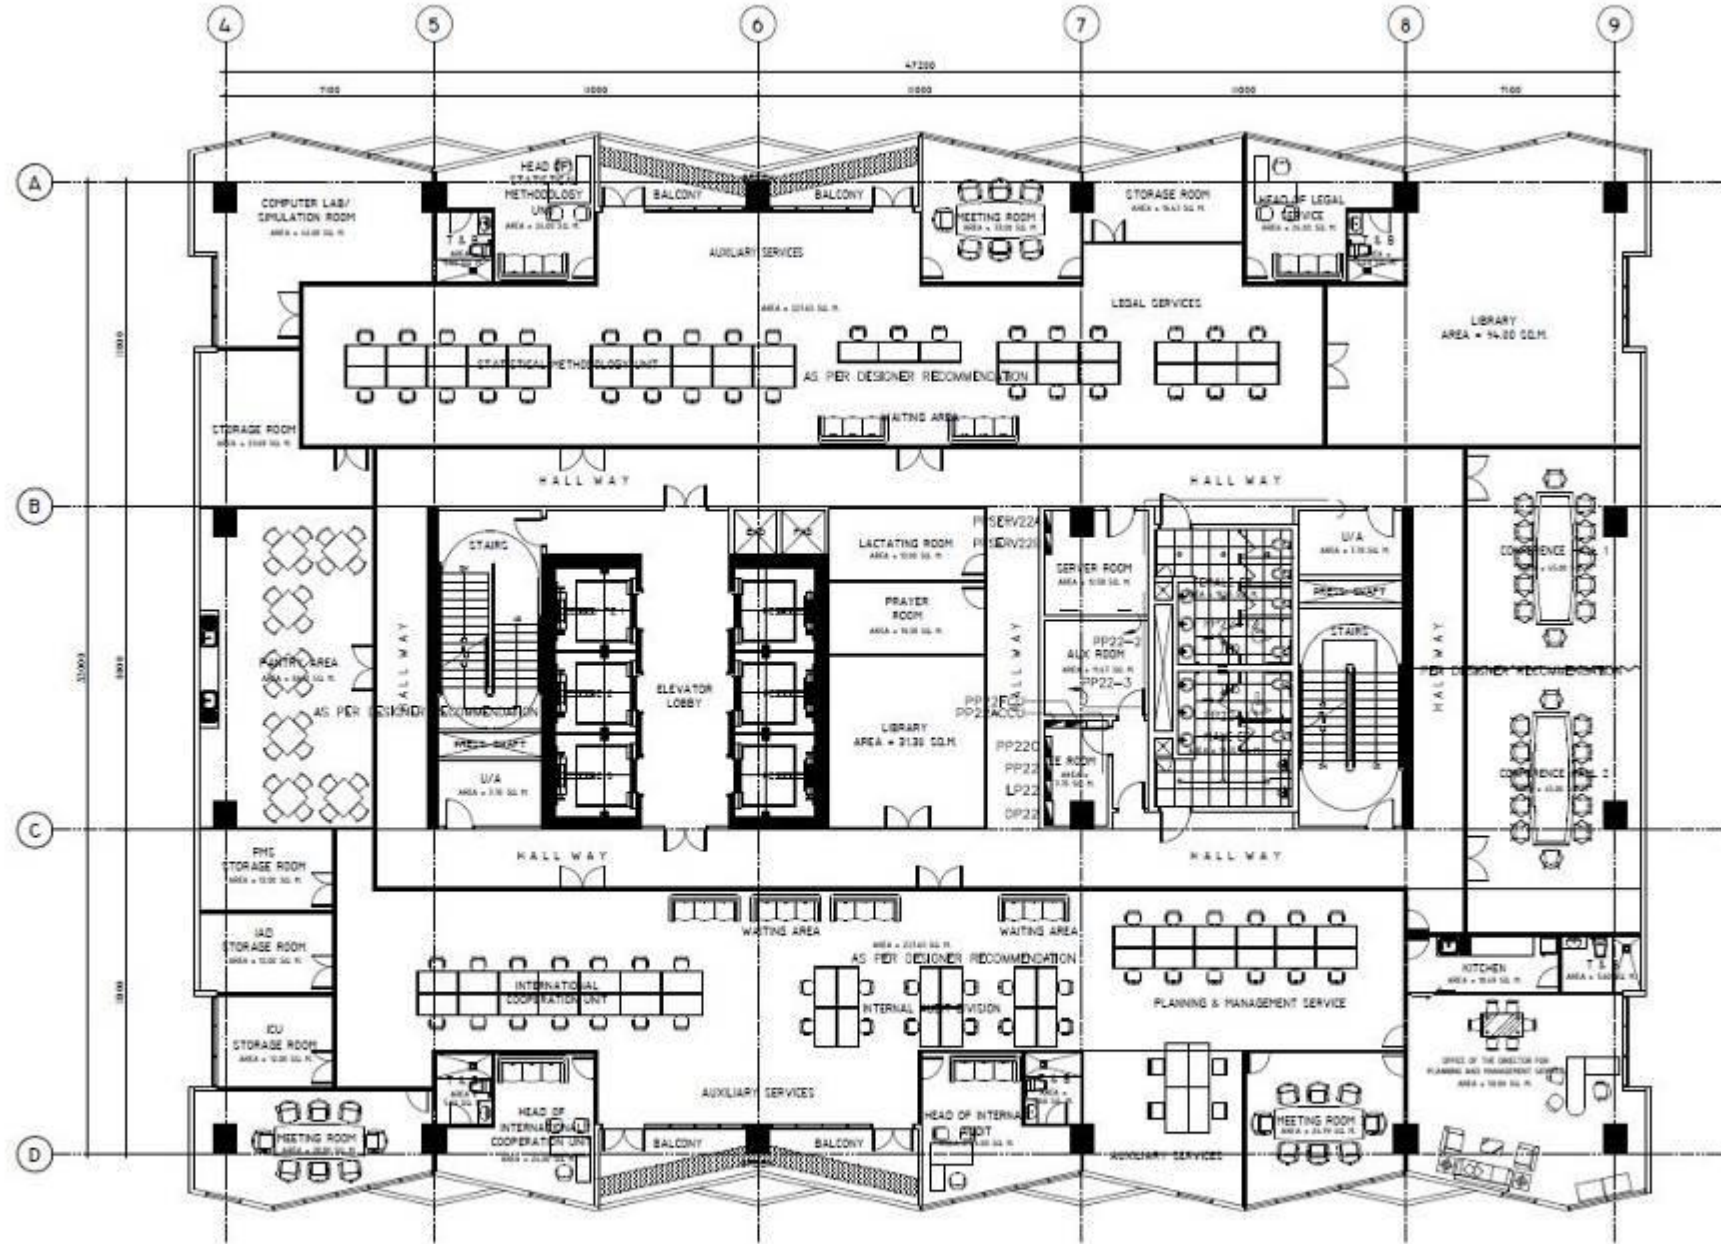


POWER LAYOUT
 SCALE: 1:200 MTS

OFFICE OF THE NATIONAL STATISTICIAN (ONS) UNITS

TOTAL FLOOR AREA = 1,557.60 sqm.
 22nd FLOOR

ELECTRICAL PLANS

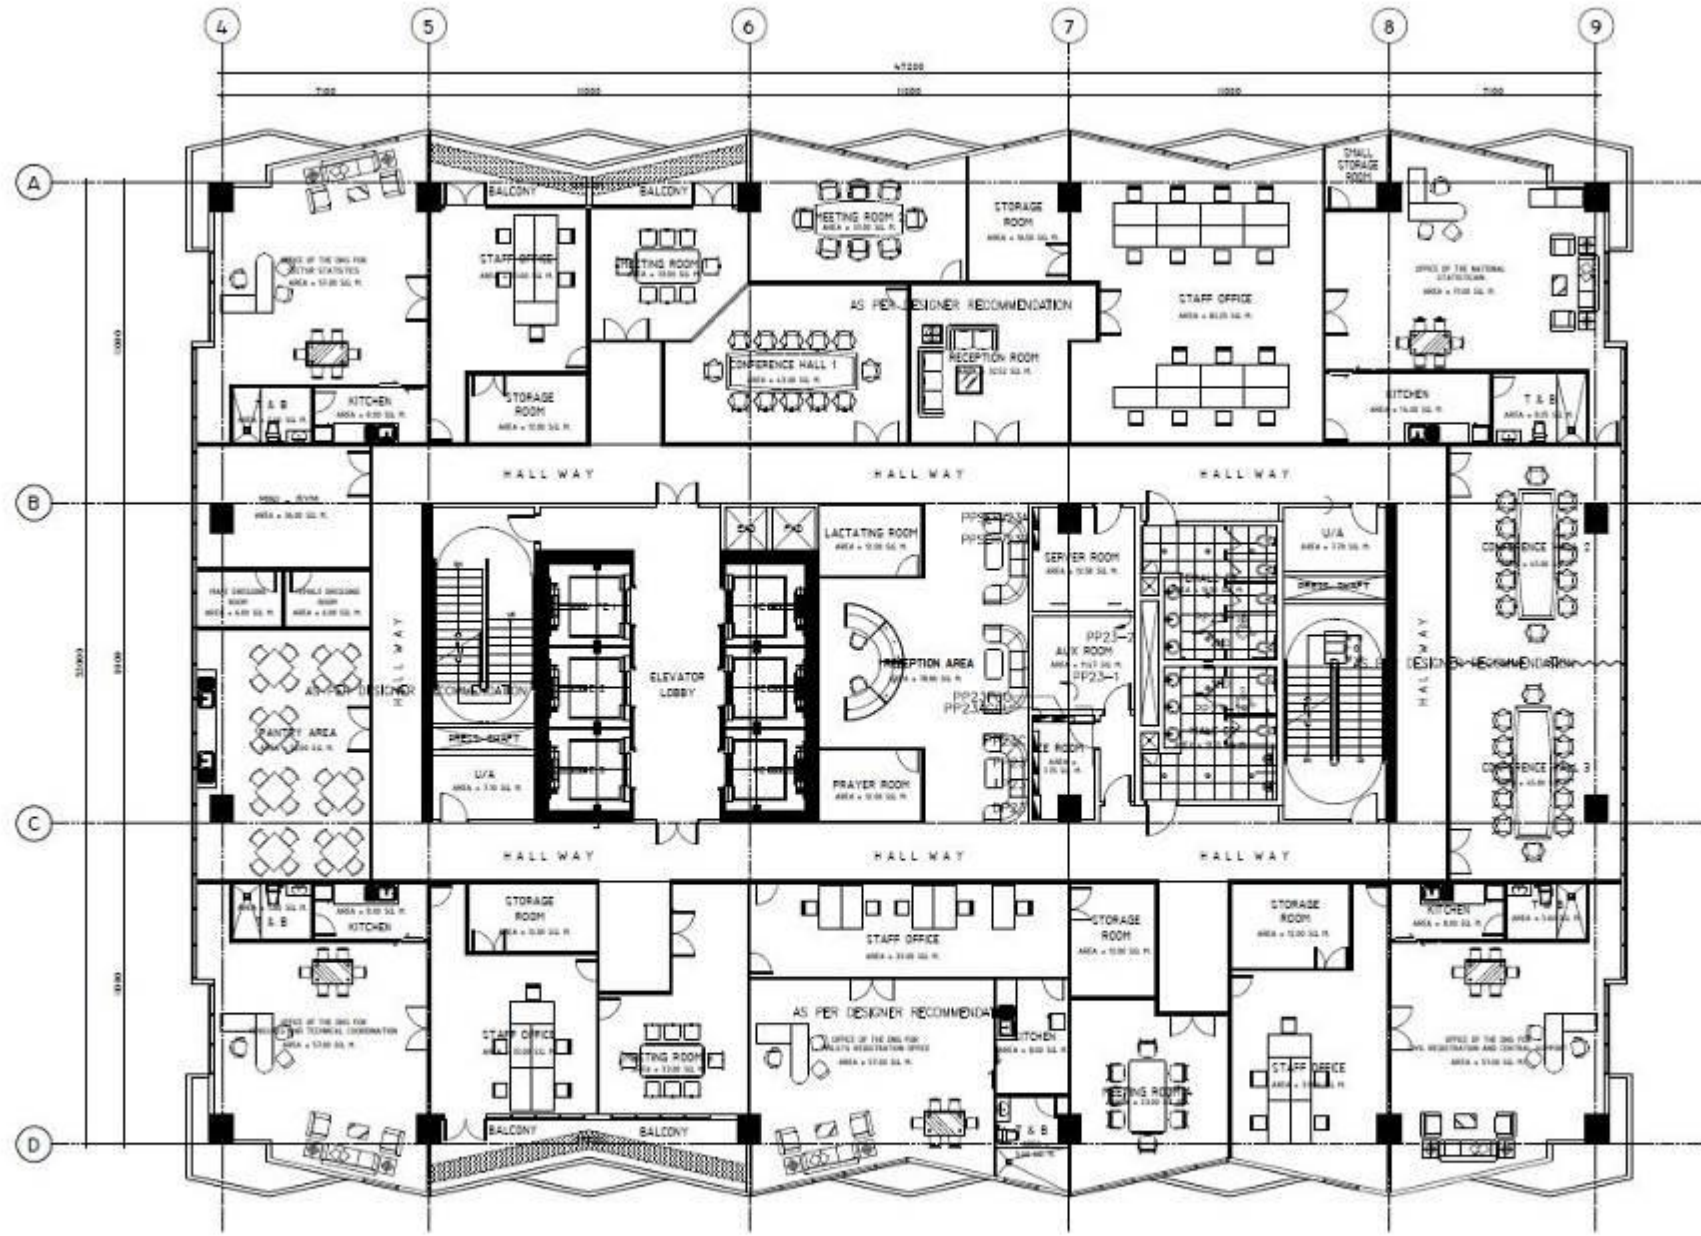


POWER LAYOUT
 SCALE: 1:200 MTS

OFFICE OF THE NATIONAL STATISTICIAN &
 OFFICE OF THE DEPUTY NATIONAL STATISTICIAN

TOTAL FLOOR AREA = 1,557.60 sq.m.
 23rd FLOOR

ELECTRICAL PLANS

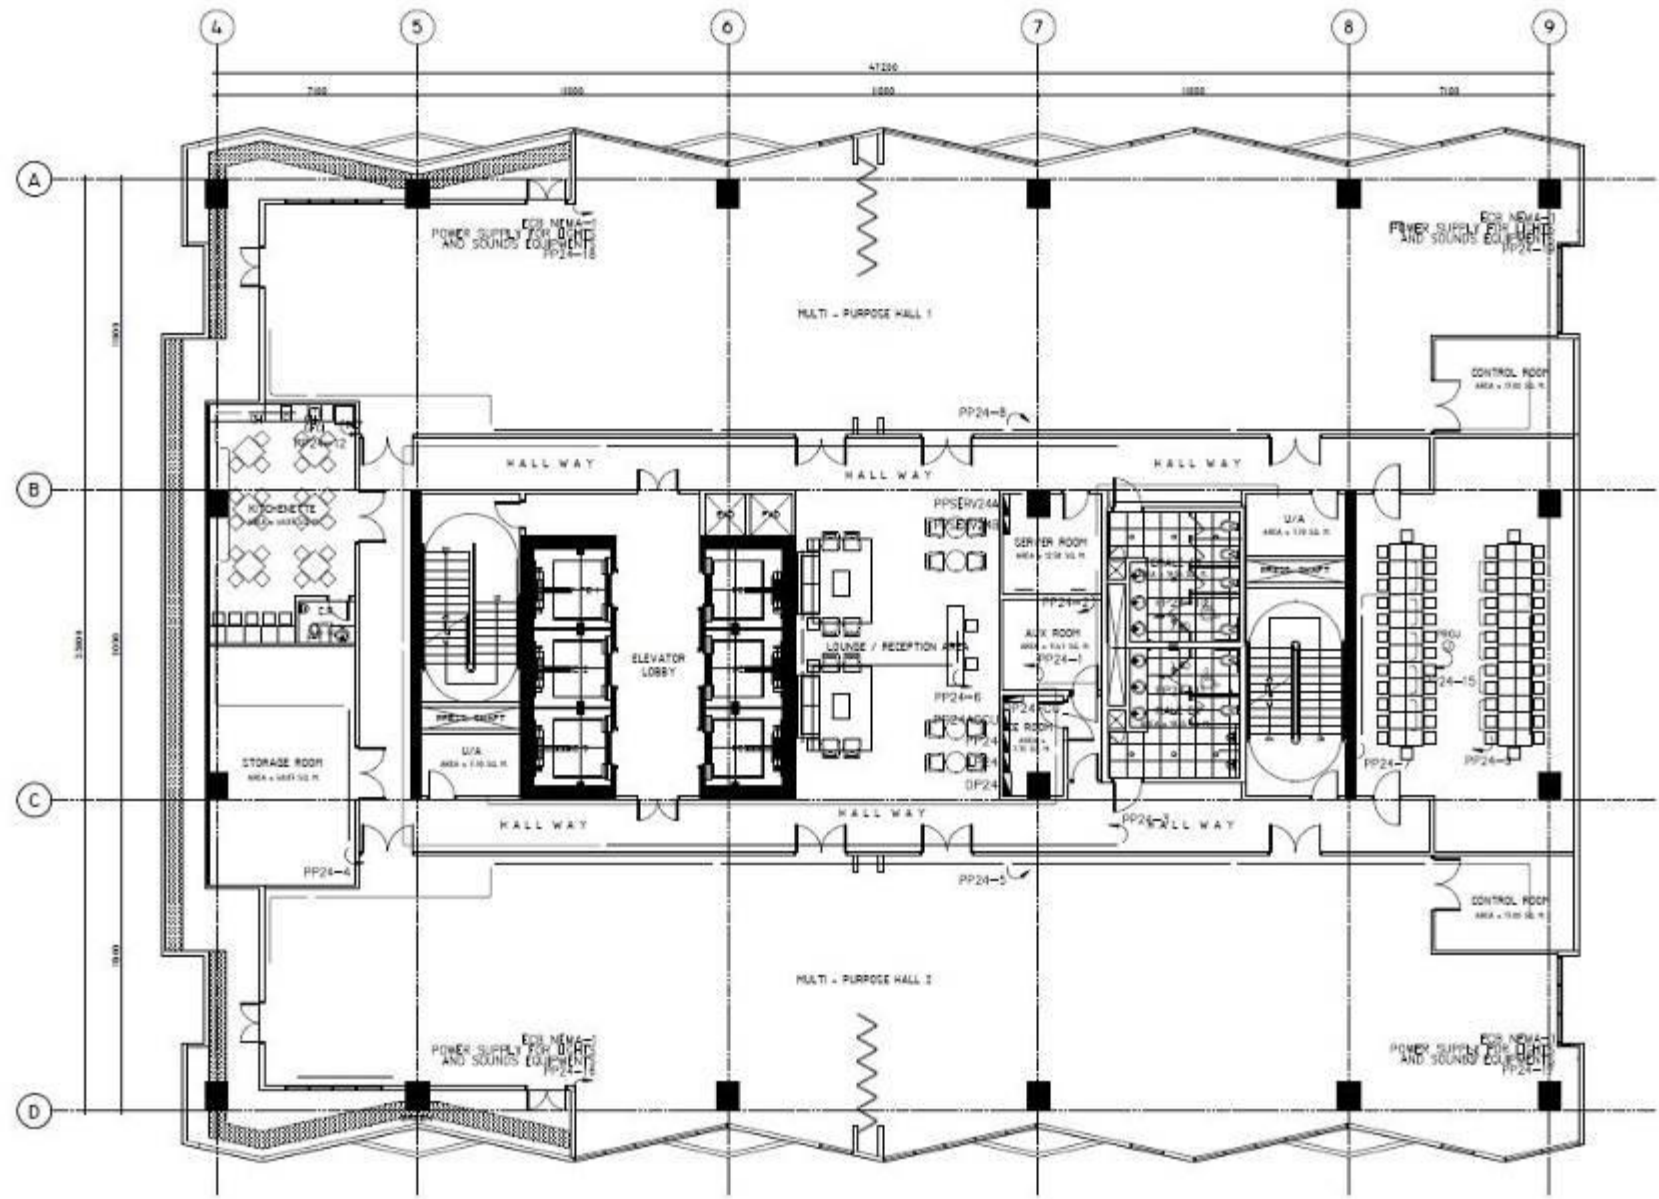


POWER LAYOUT
SCALE: 1:200 MTS

MULTI-PURPOSE HALL &
MAIN CONFERENCE ROOM

TOTAL FLOOR AREA = 1,557.60 sq.m.
24th FLOOR


ELECTRICAL PLANS

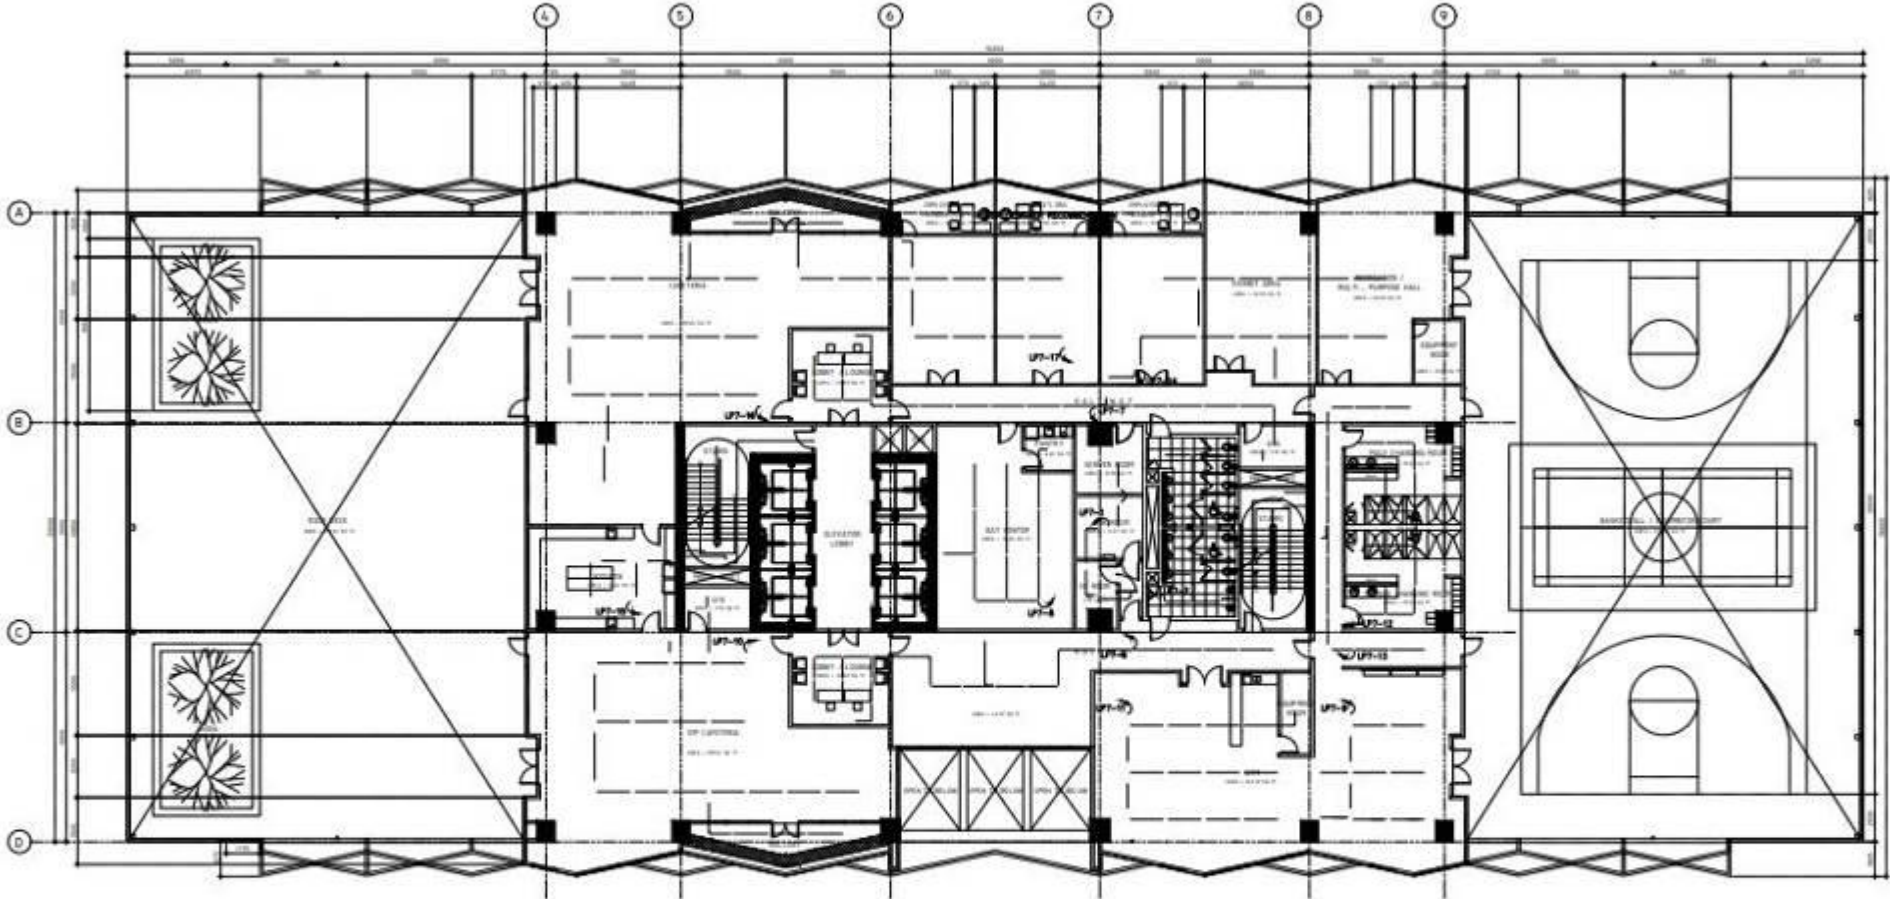

LIGHTING LAYOUT
SCALE 1:200MTS

7th FLOOR


ELECTRICAL PLANS

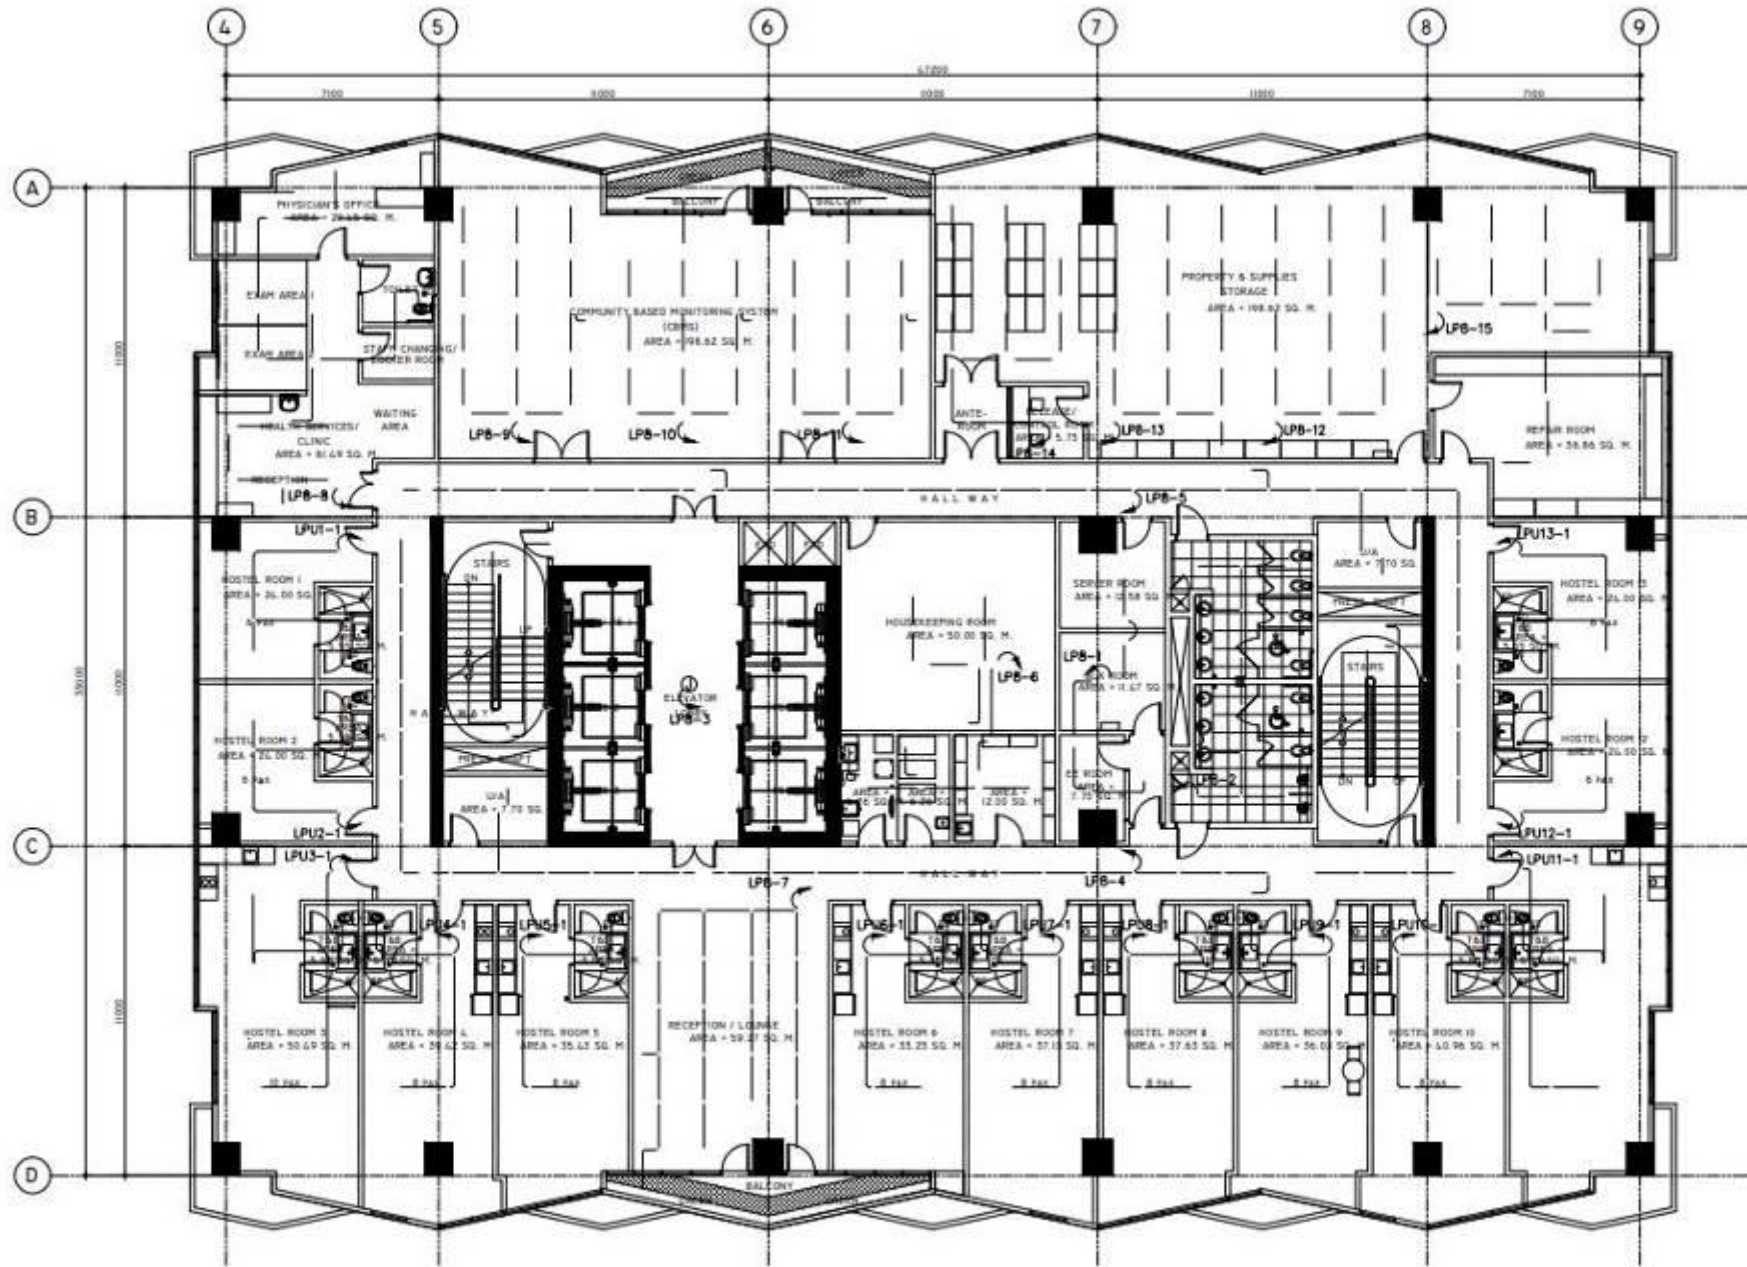

LIGHTING LAYOUT
SCALE 1:200M/T

8th FLOOR


ELECTRICAL PLANS

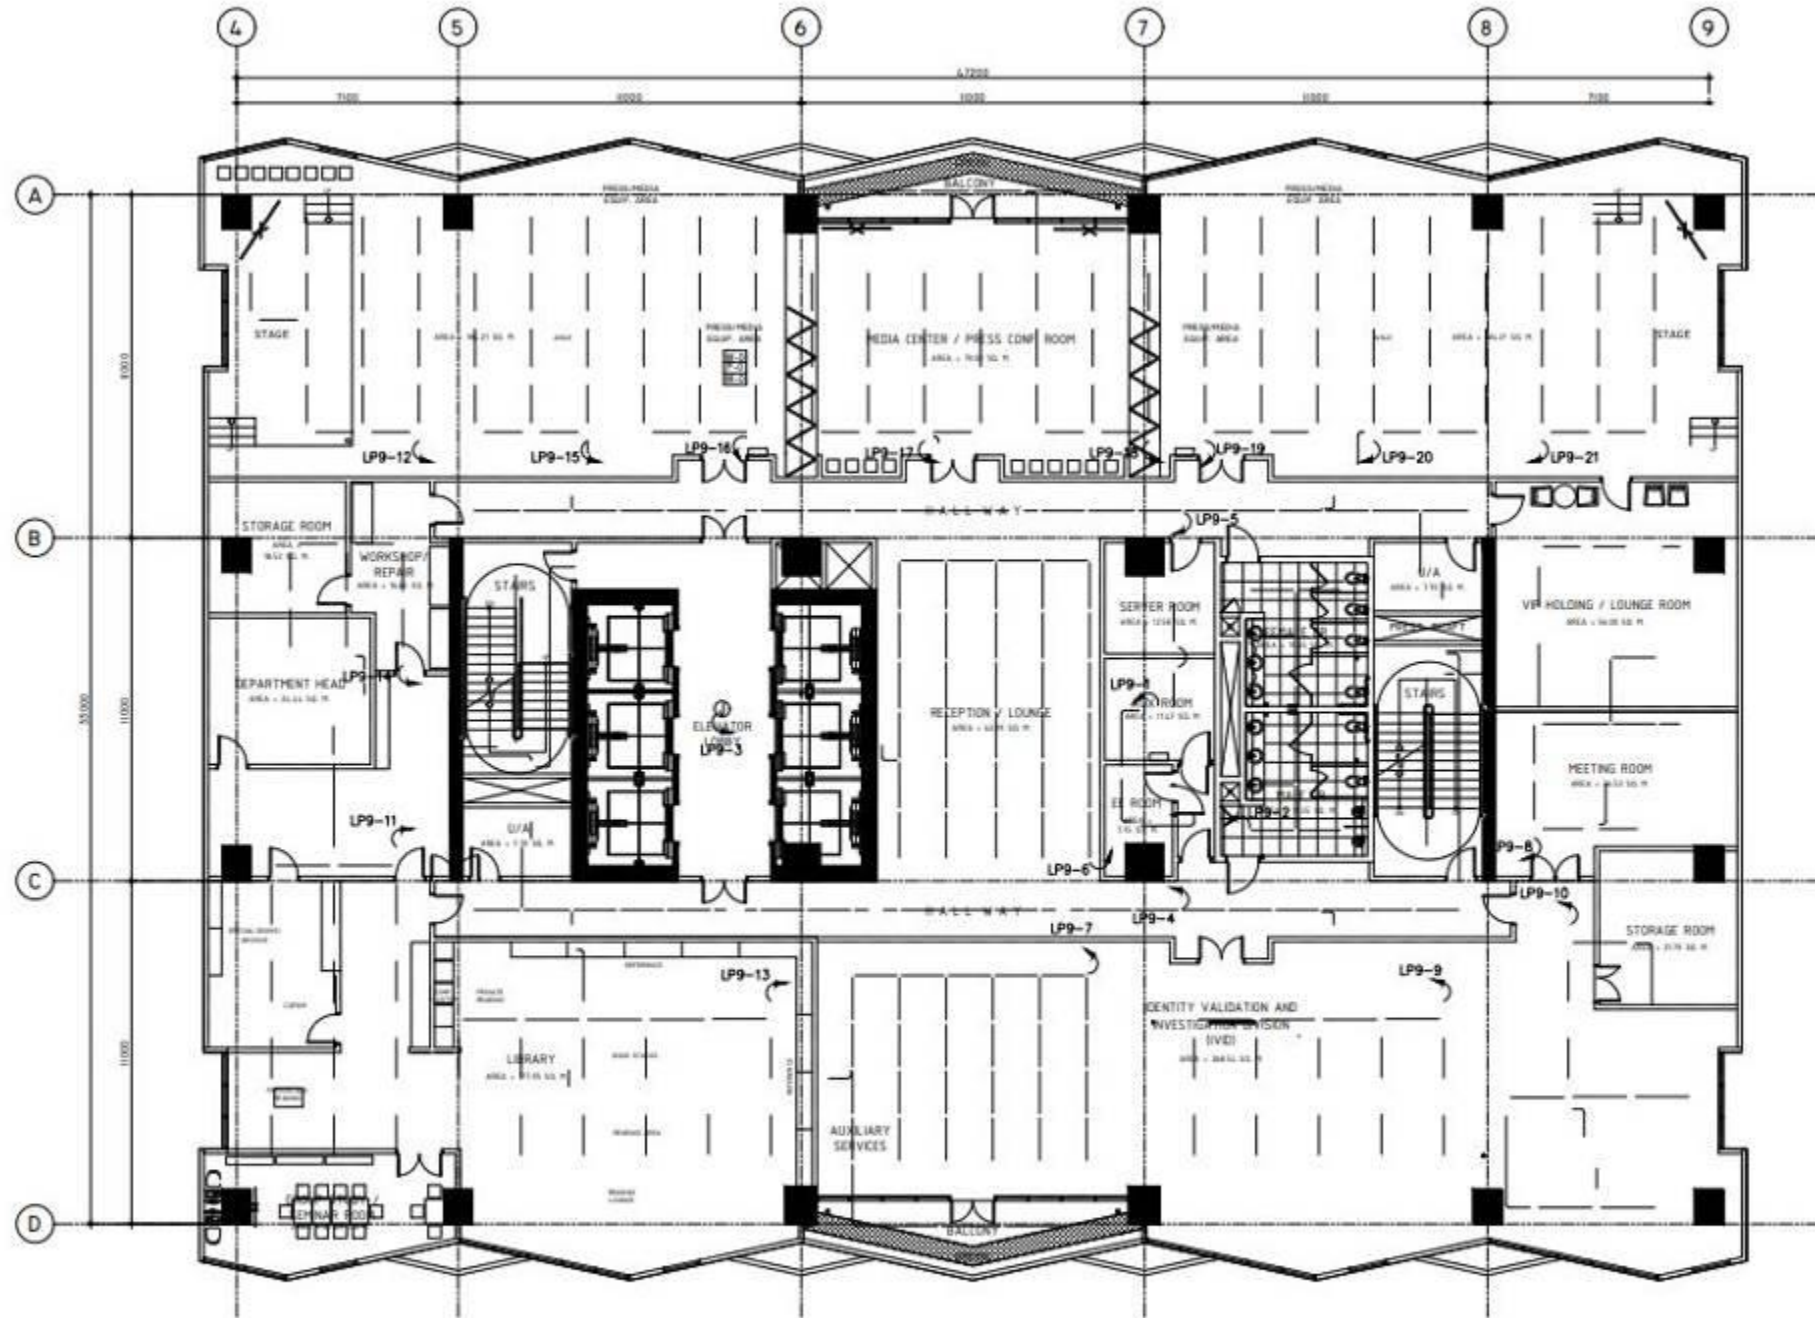

LIGHTING LAYOUT
SCALE 1:200MTS

9th FLOOR


ELECTRICAL PLANS

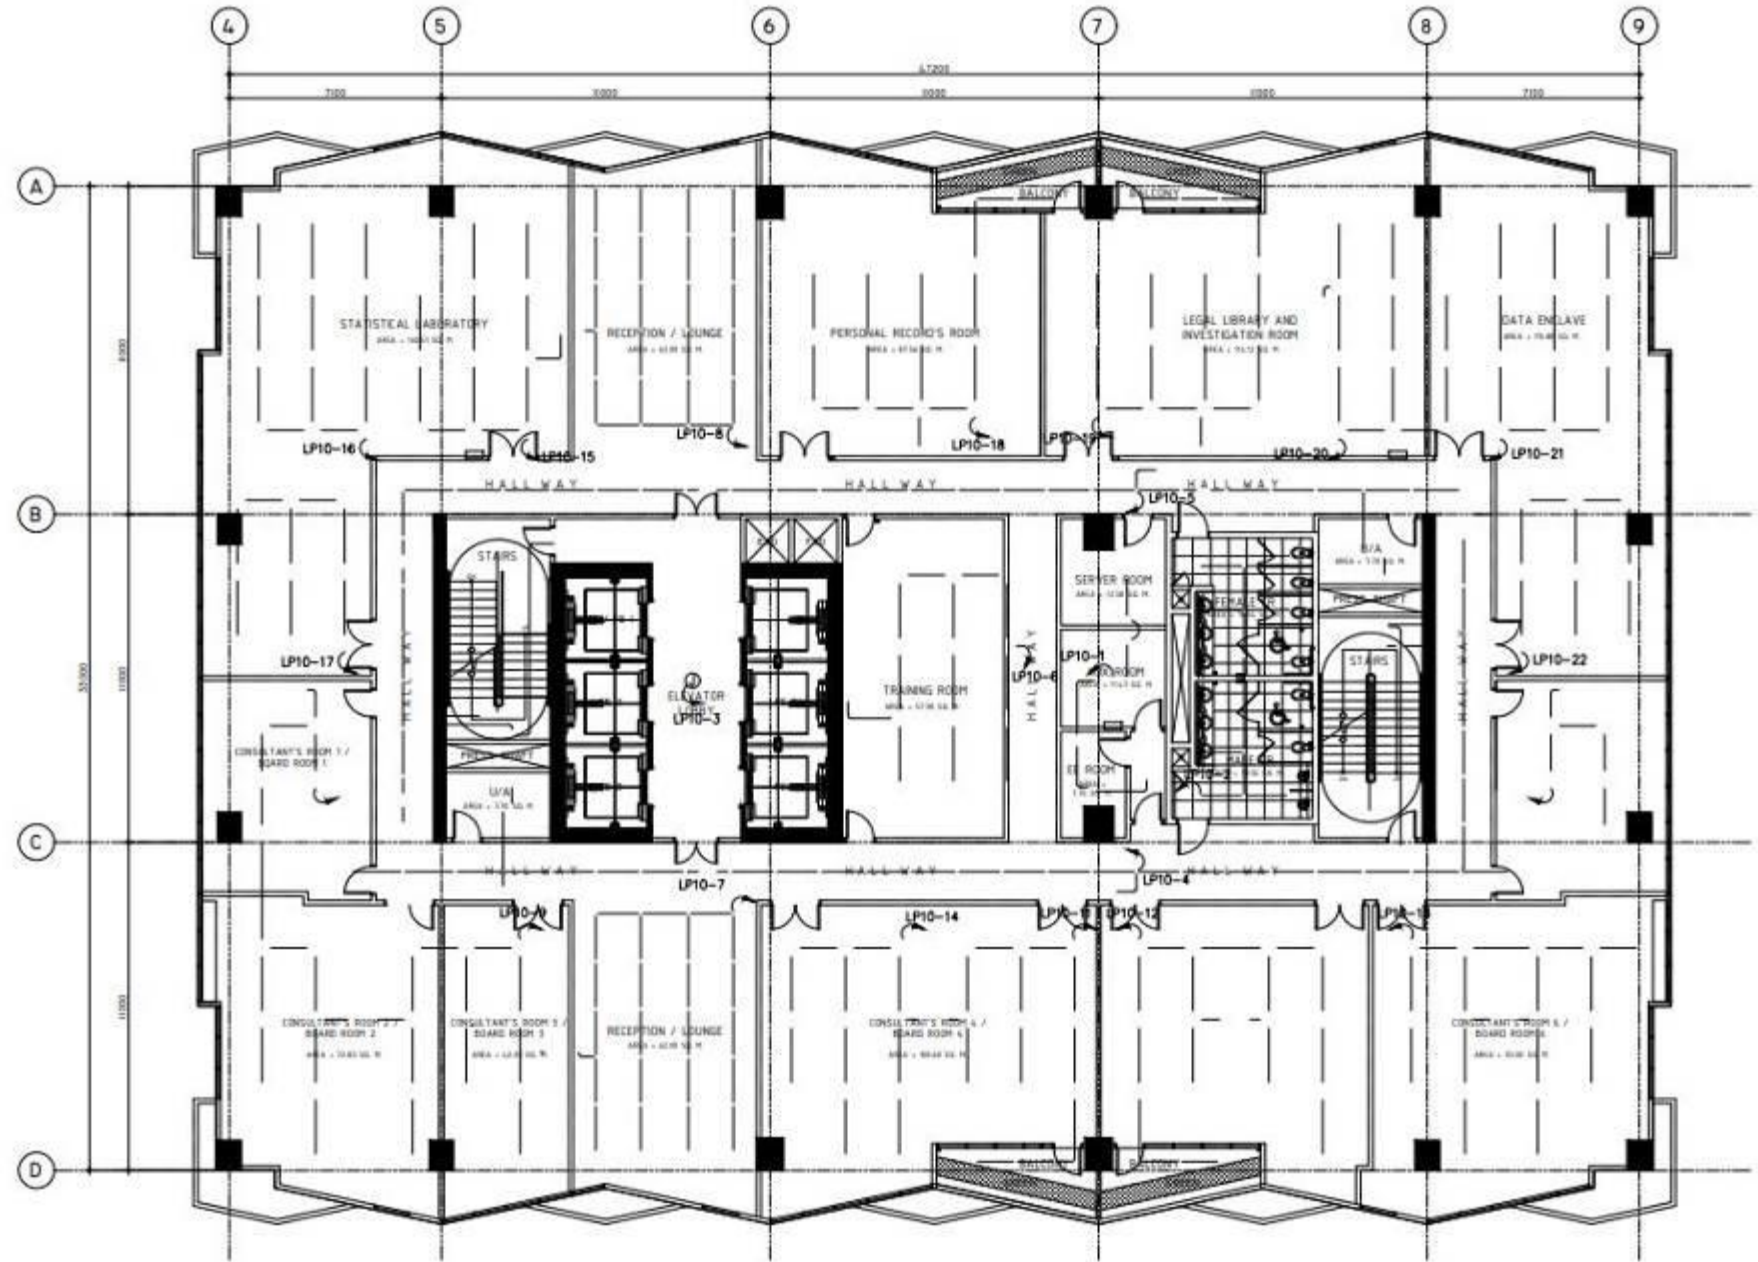

LIGHTING LAYOUT
SCALE 1:200MTS

10th FLOOR


ELECTRICAL PLANS

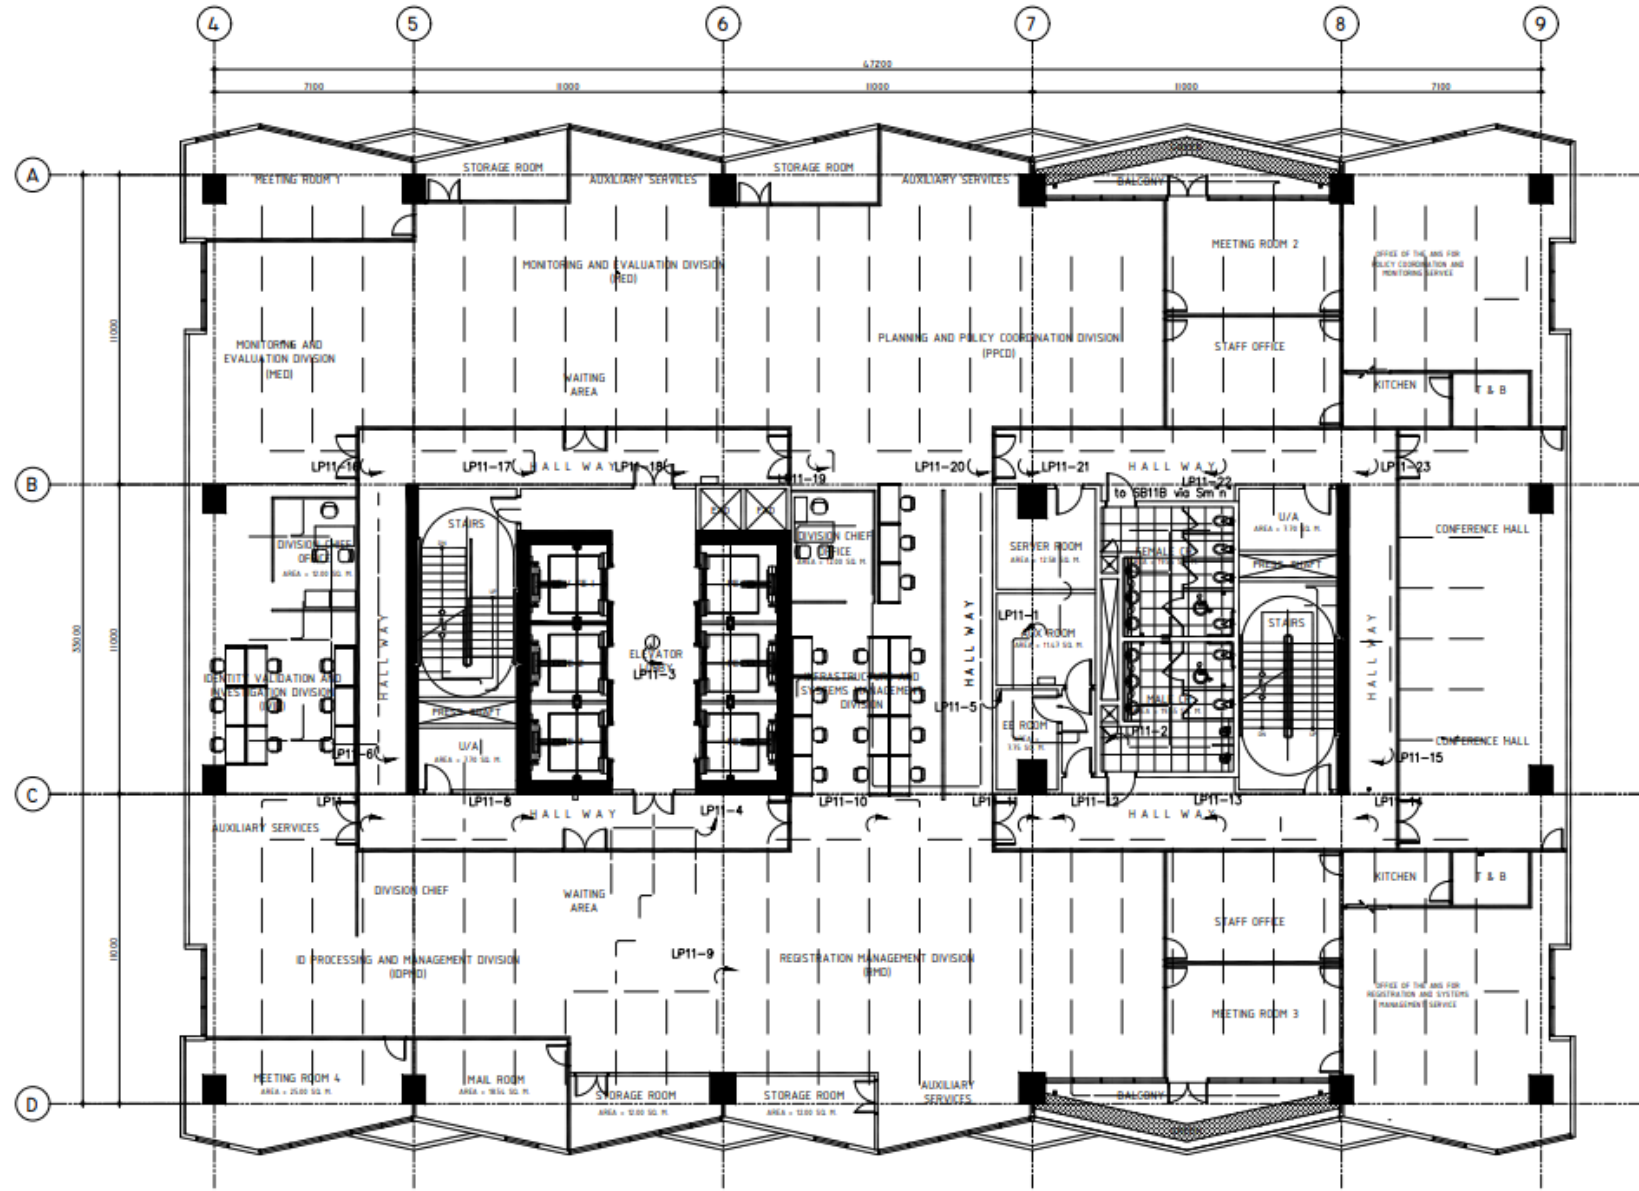

○ LIGHTING LAYOUT
 ○ SCALE 1:200 MTS

11th FLOOR


ELECTRICAL PLANS

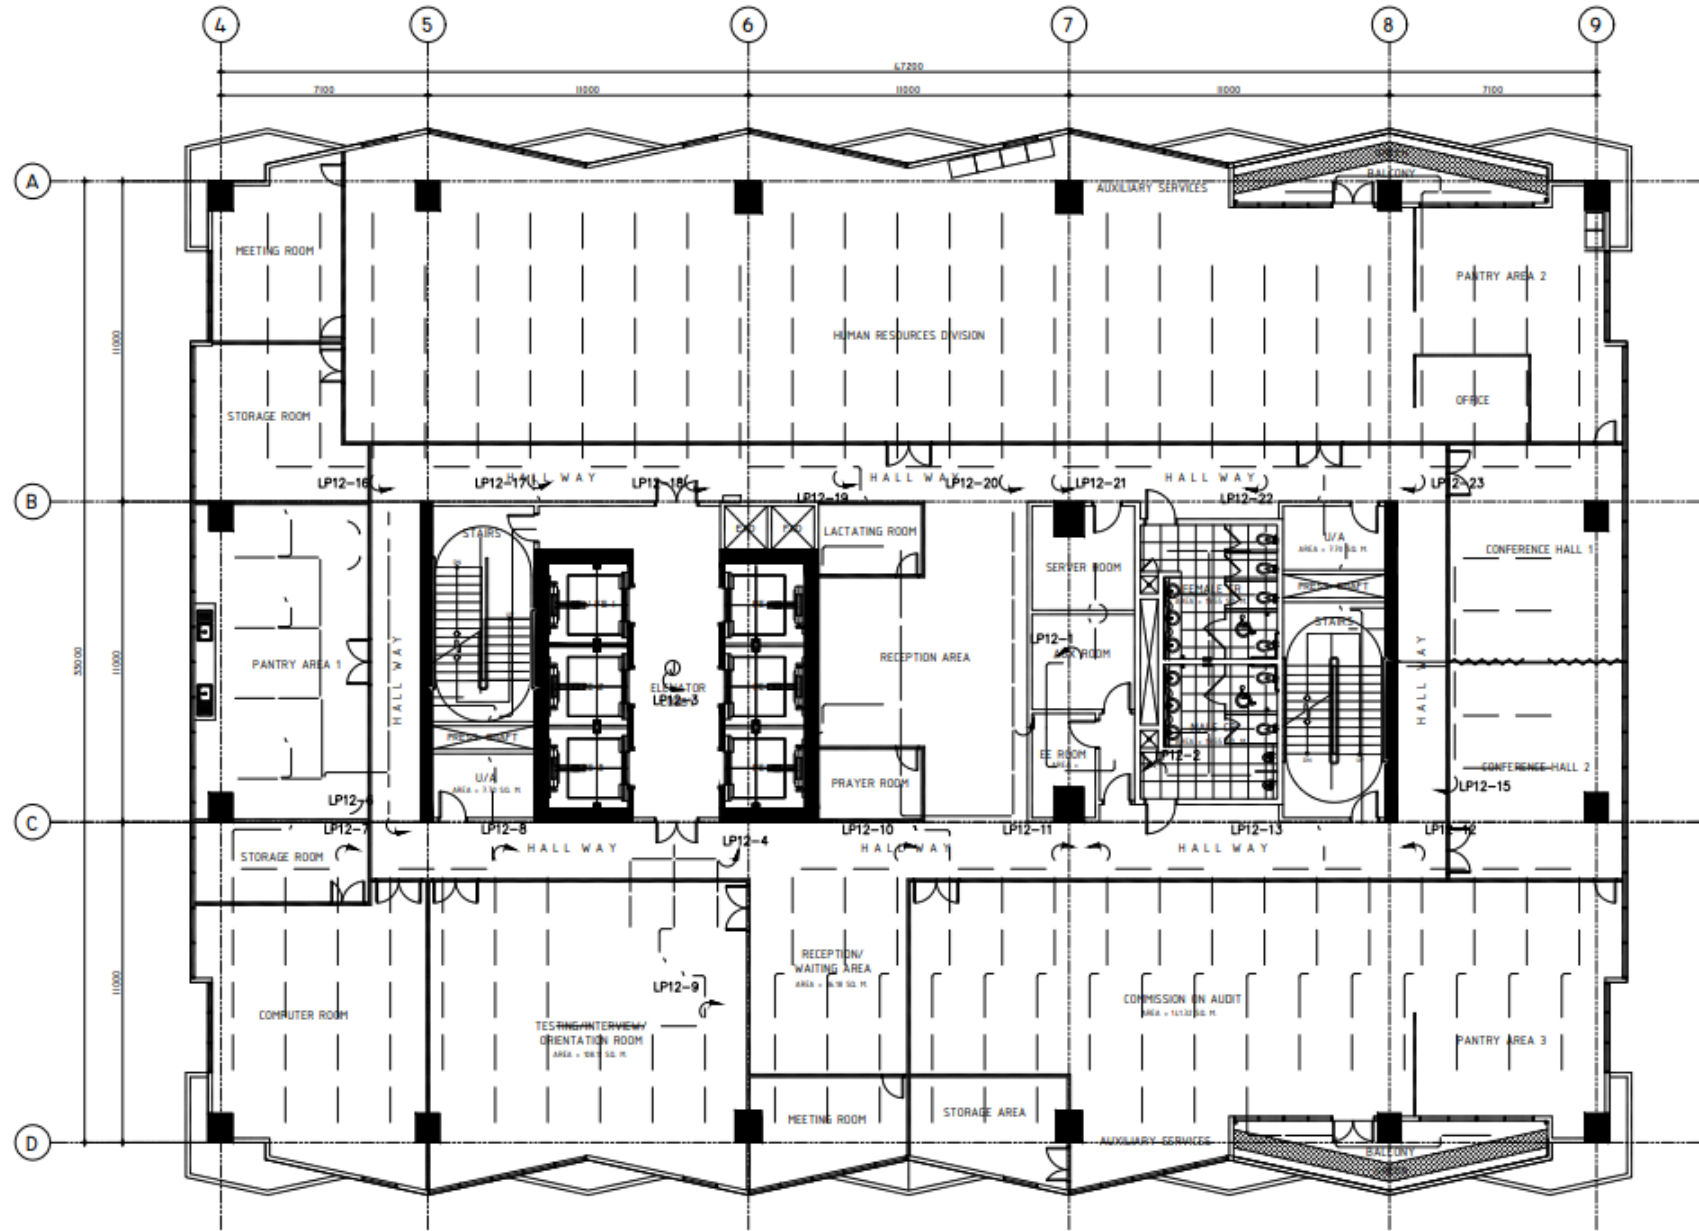

LIGHTING LAYOUT
SCALE 1:200 MTS

12th FLOOR


ELECTRICAL PLANS

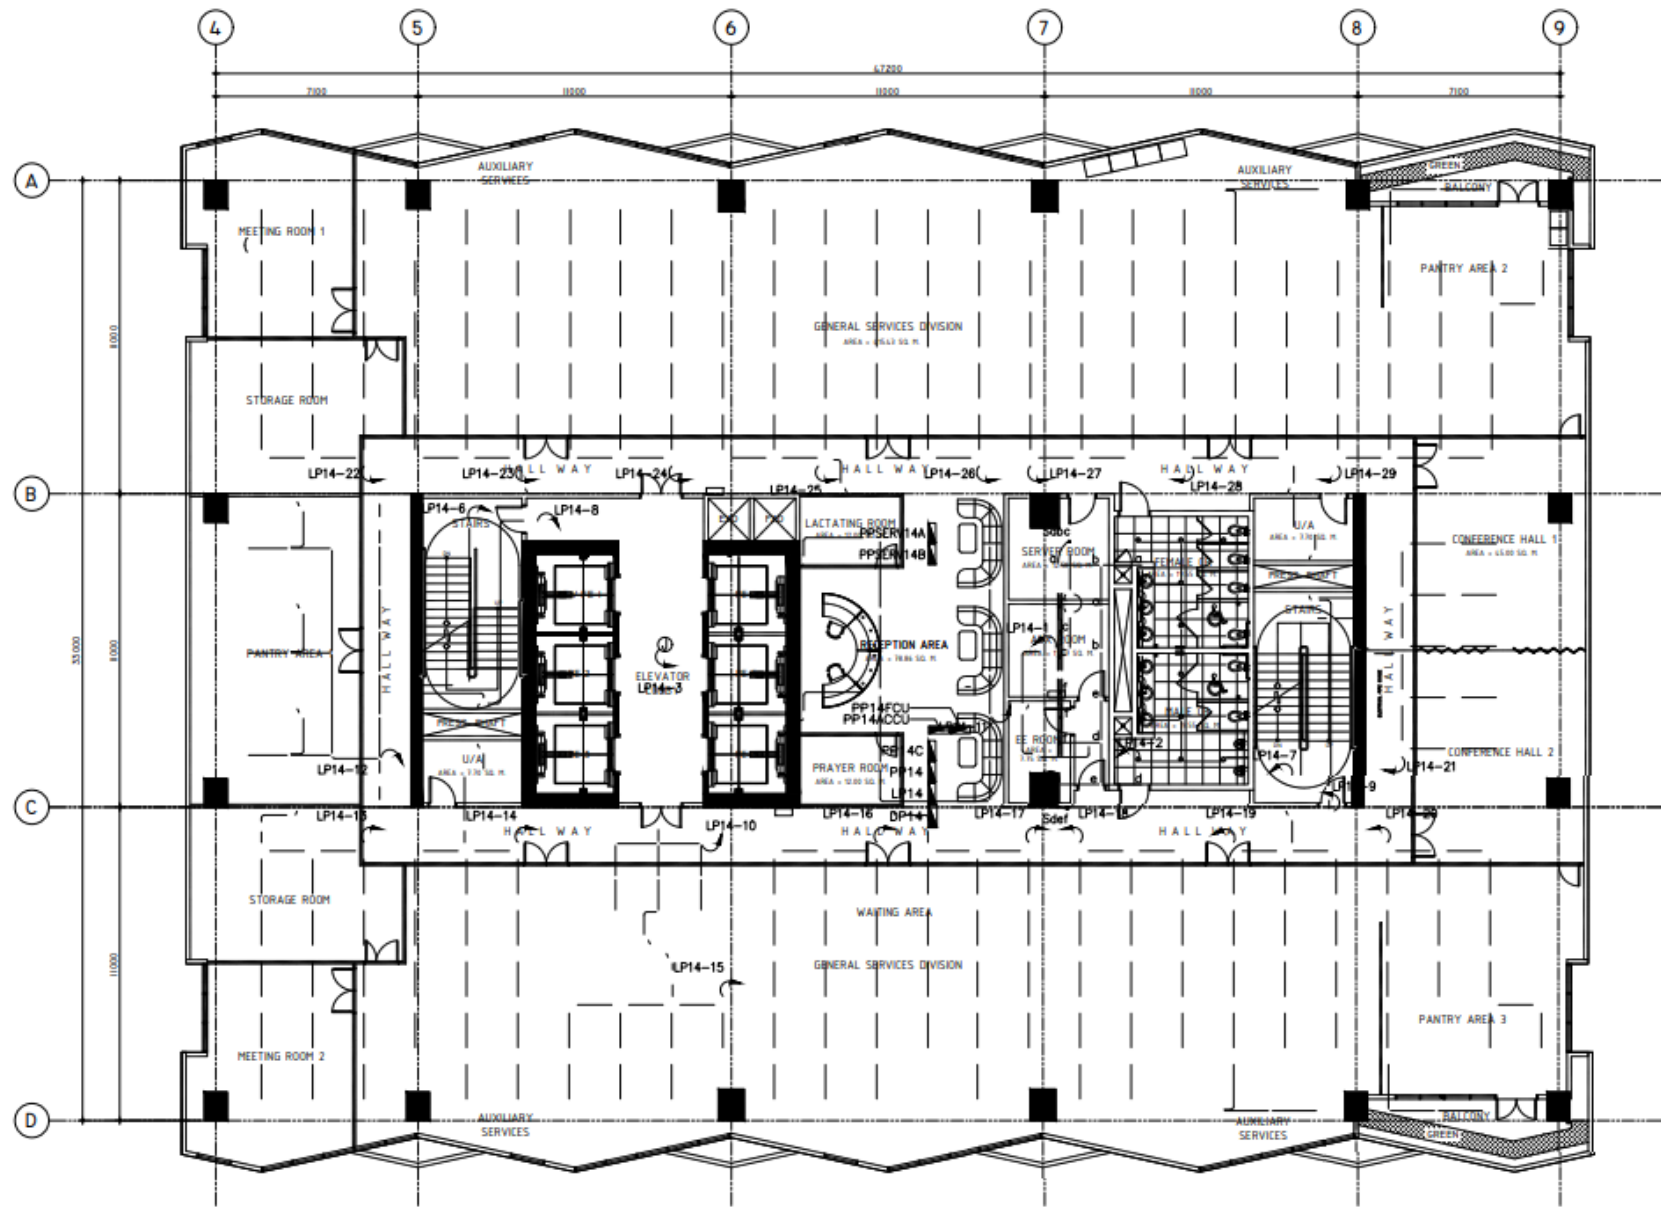

LIGHTING LAYOUT
SCALE 1:200 MTS

14th FLOOR

ELECTRICAL PLANS

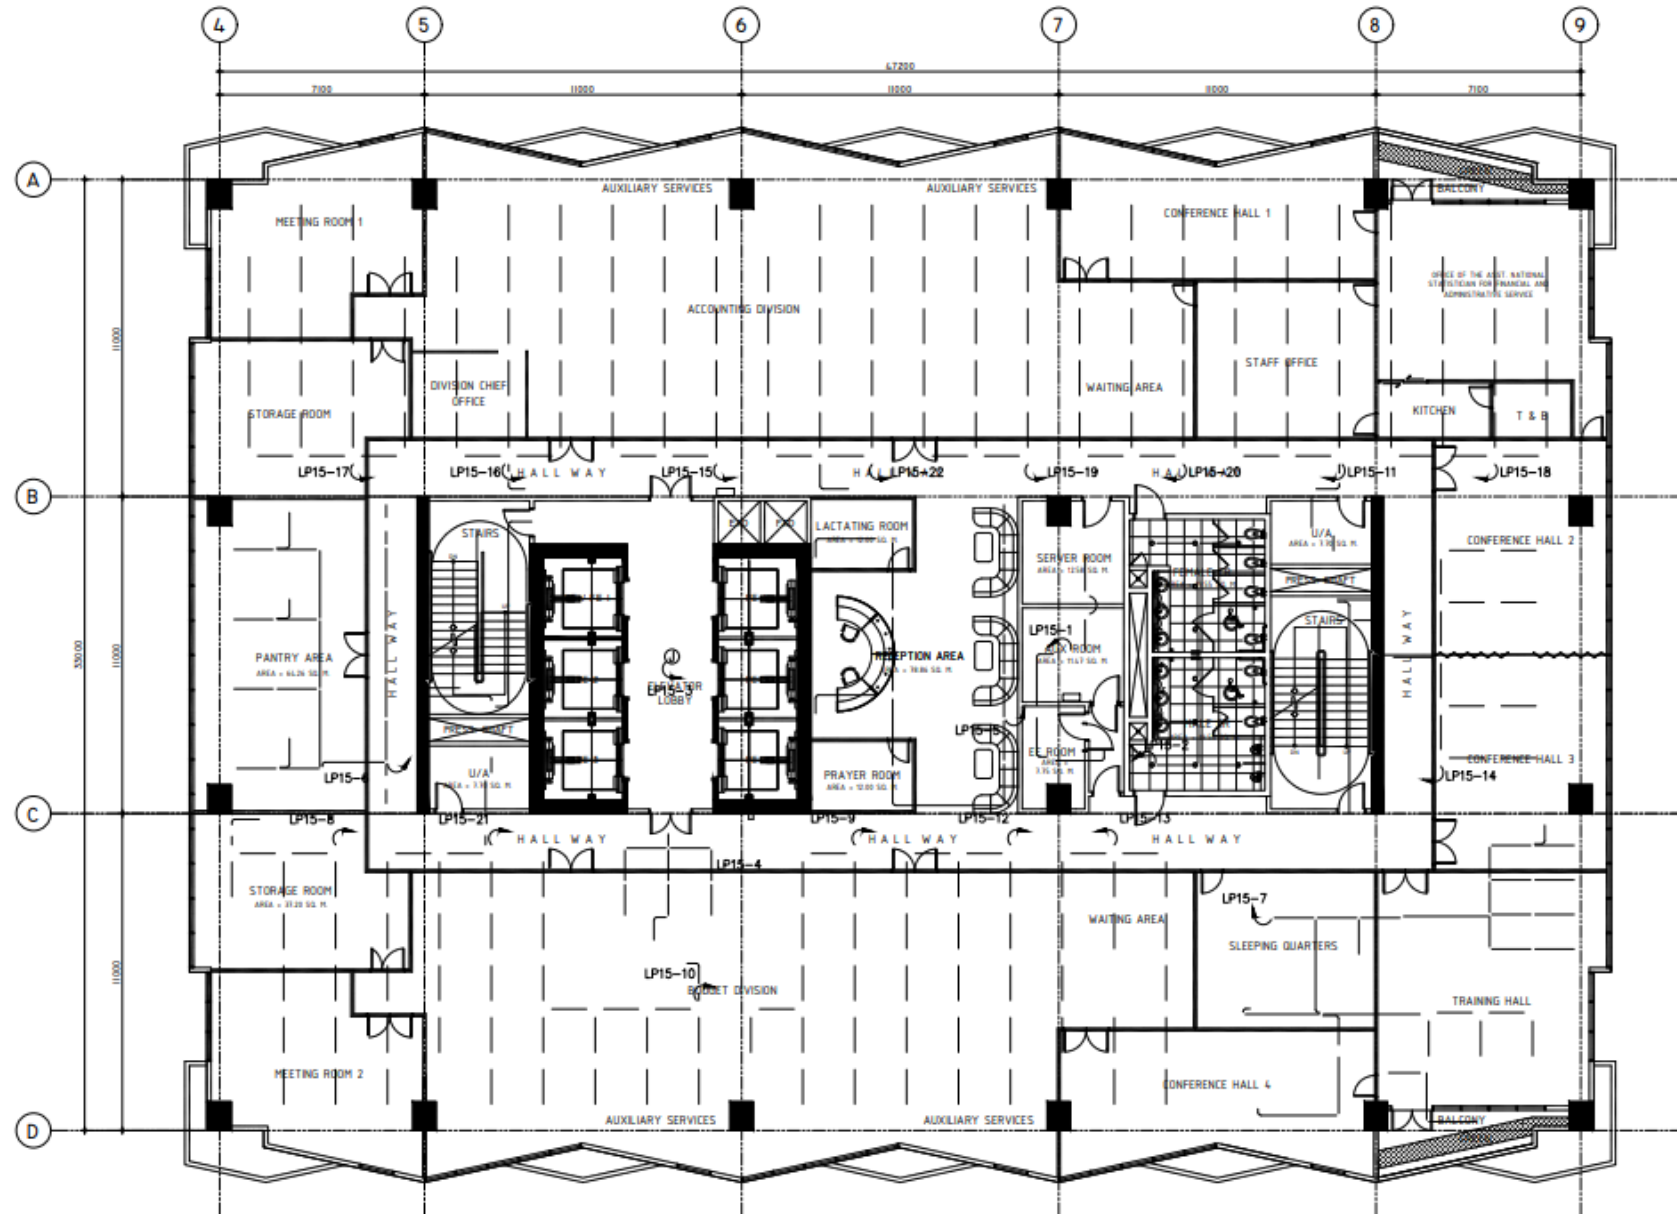

LIGHTING LAYOUT
SCALE 1:200 MTS

15th FLOOR