



ELECTRICAL PLANS

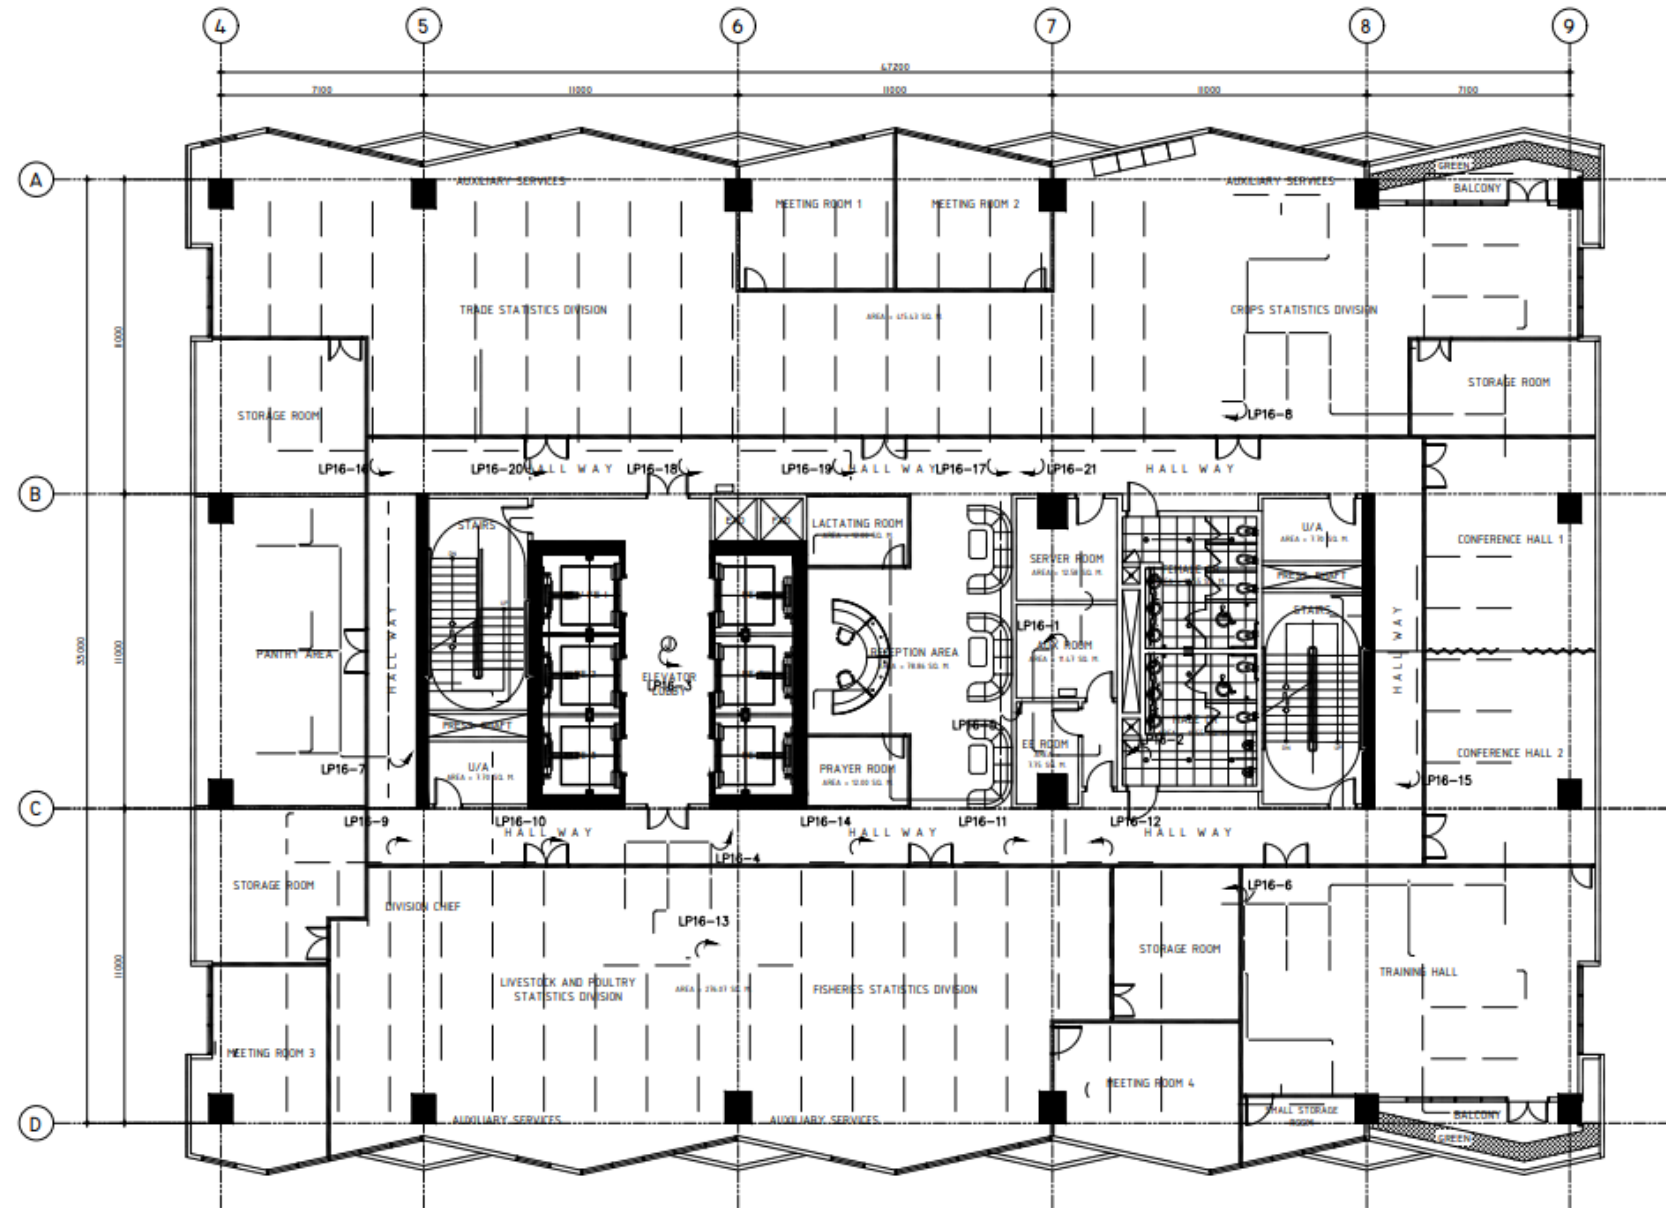

○ LIGHTING LAYOUT
SCALE 1:200 MTS

16th FLOOR


ELECTRICAL PLANS

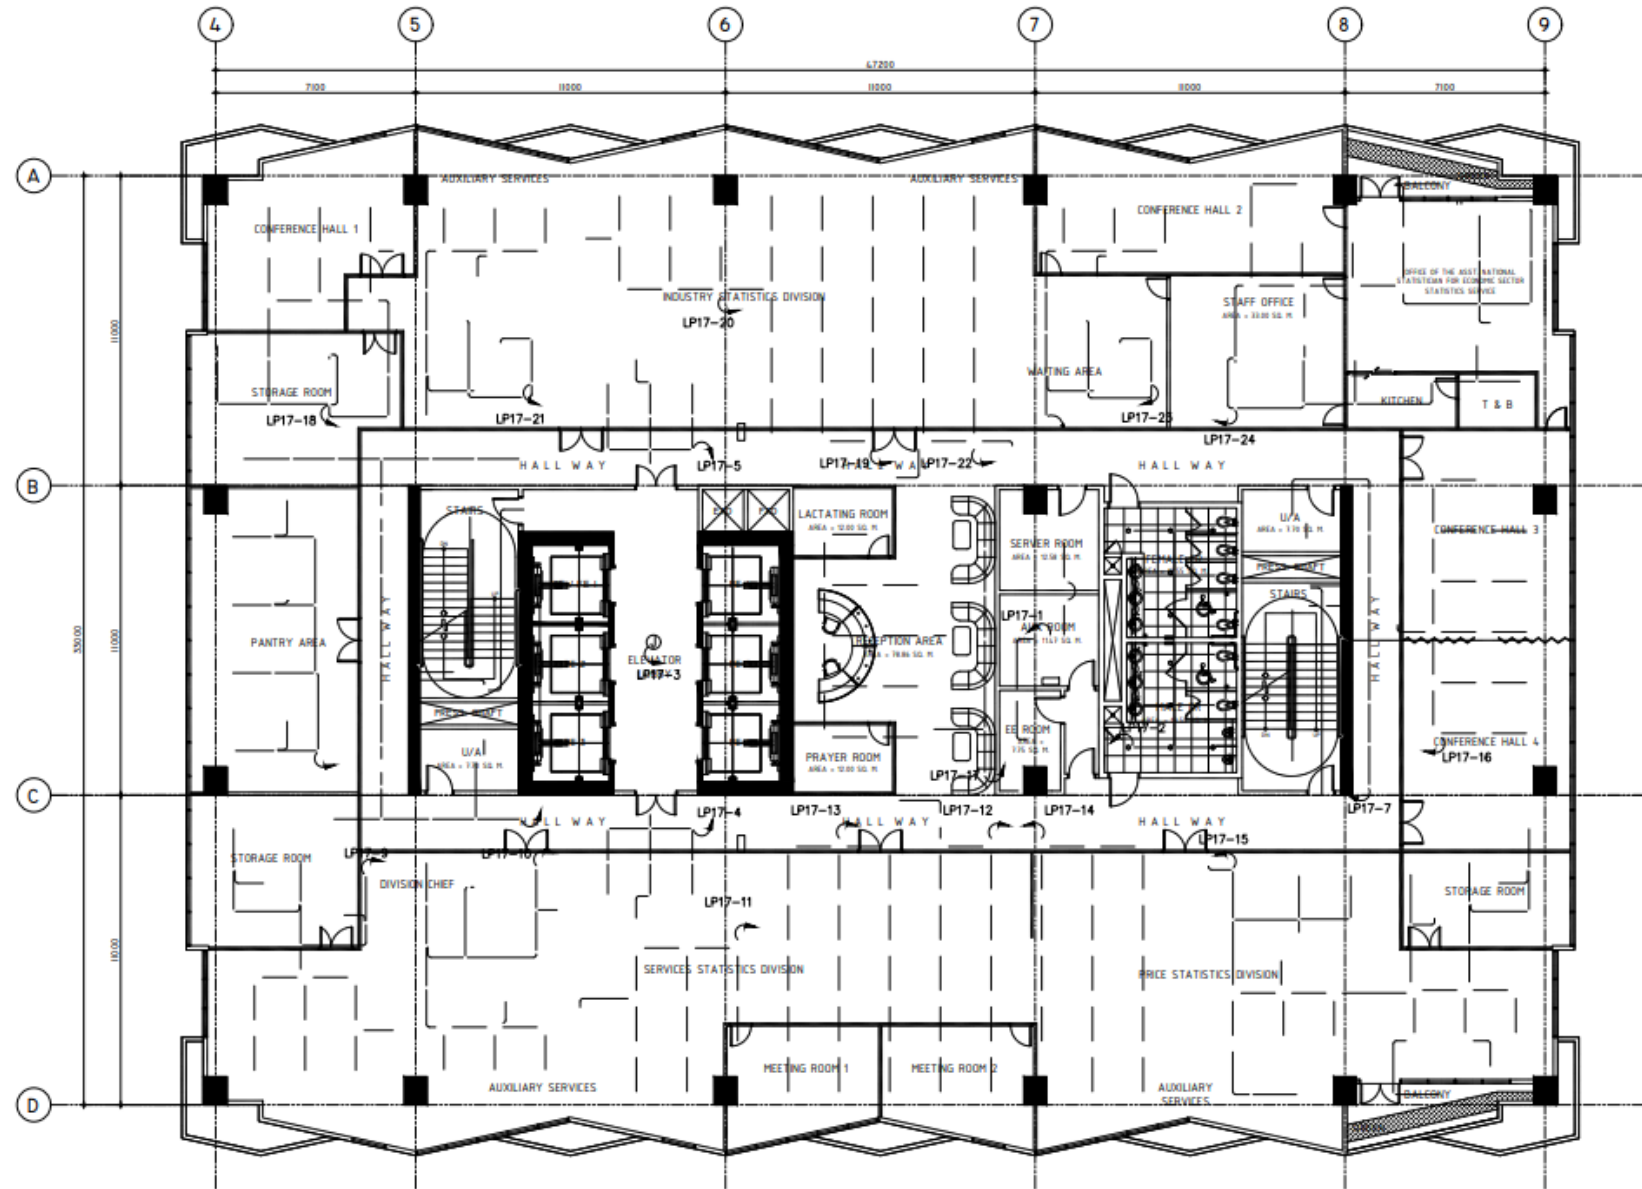

○ LIGHTING LAYOUT
SCALE 1:200 MTS

17th FLOOR


ELECTRICAL PLANS

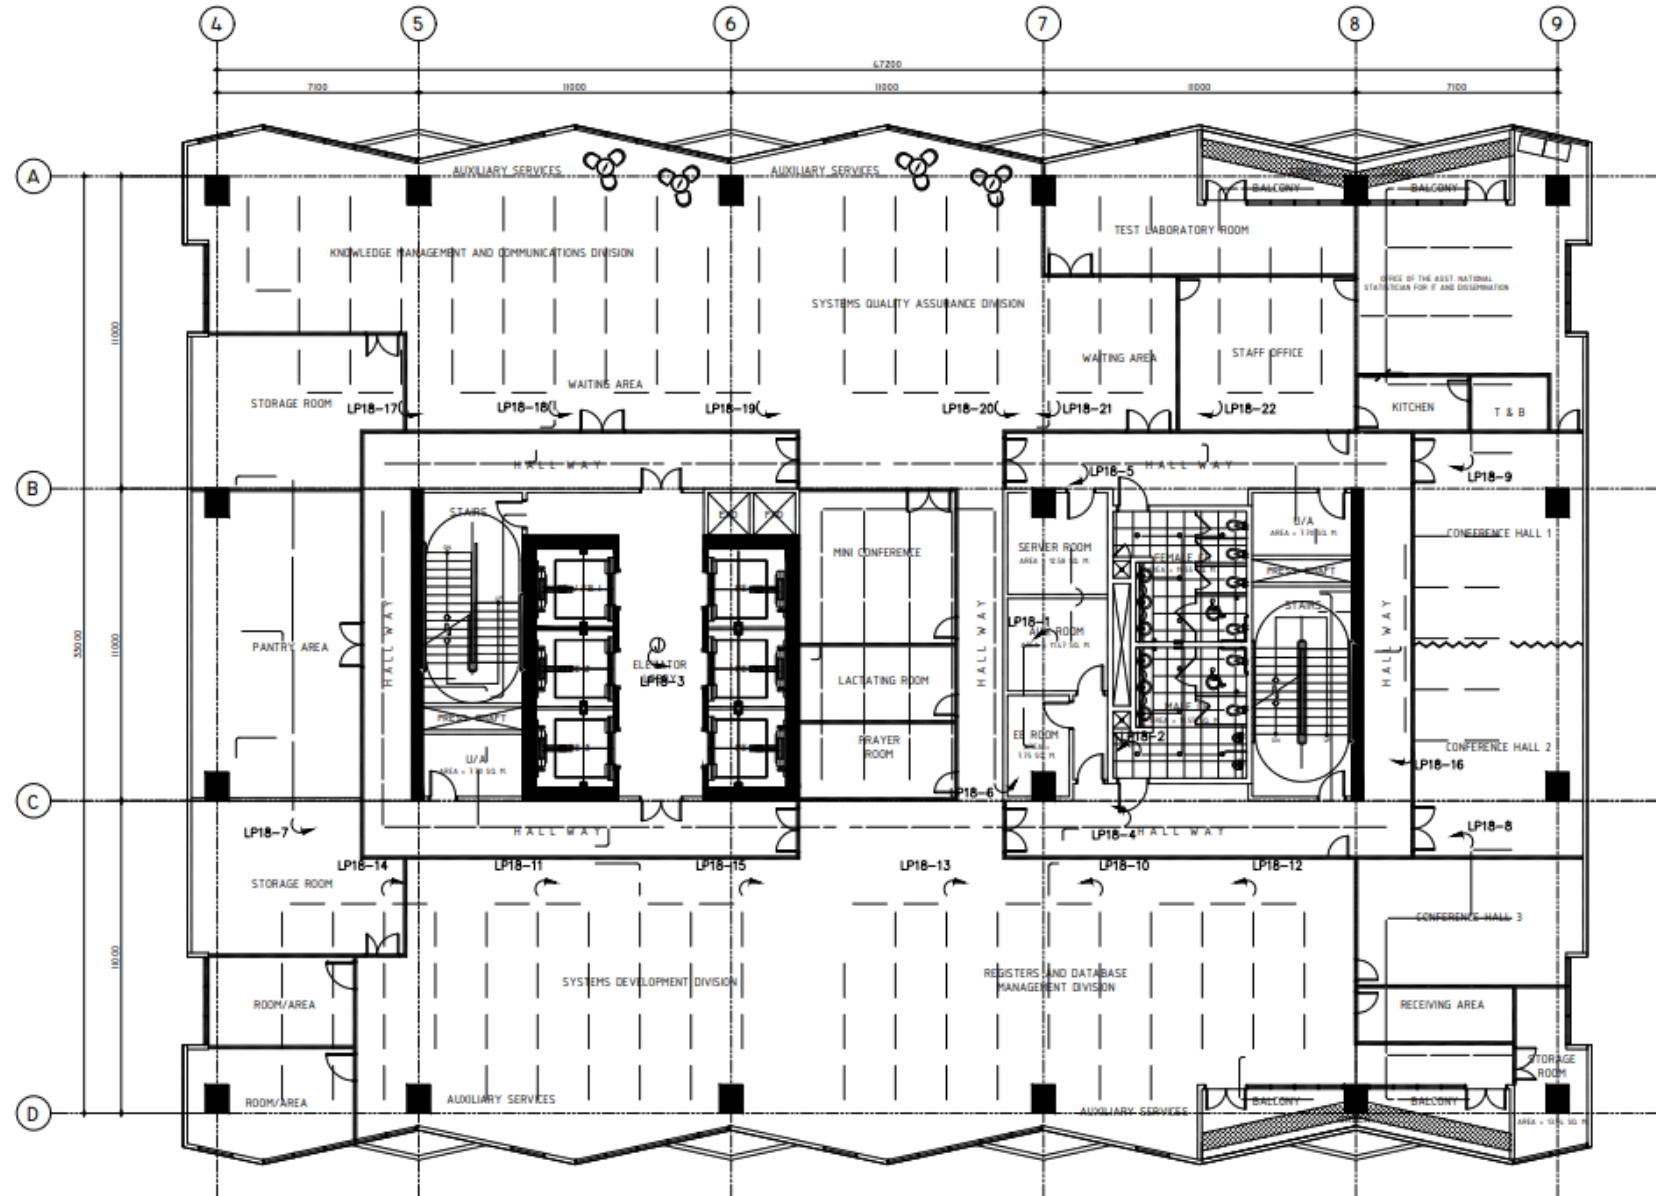

○ LIGHTING LAYOUT
SCALE 1:200 MTS

18th FLOOR


ELECTRICAL PLANS

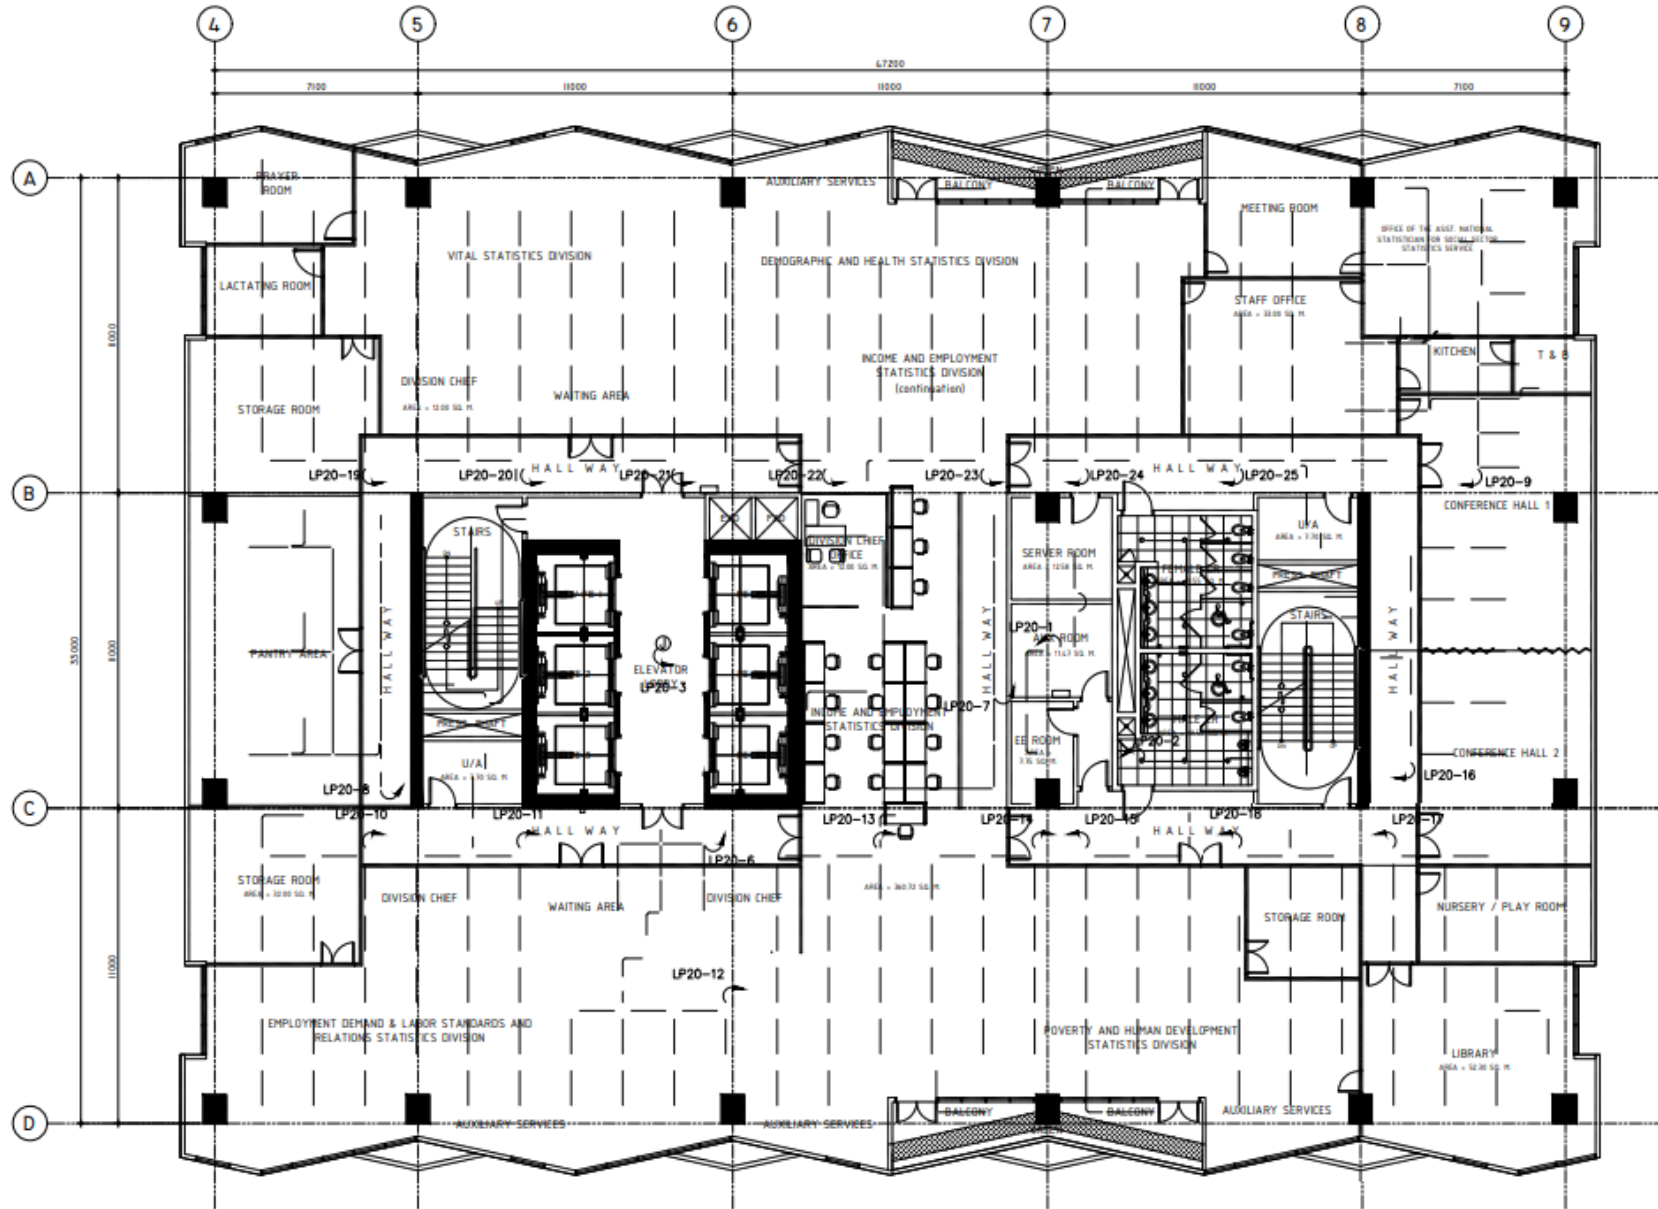

○ LIGHTING LAYOUT
SCALE 1:200 MTS

20th FLOOR


ELECTRICAL PLANS

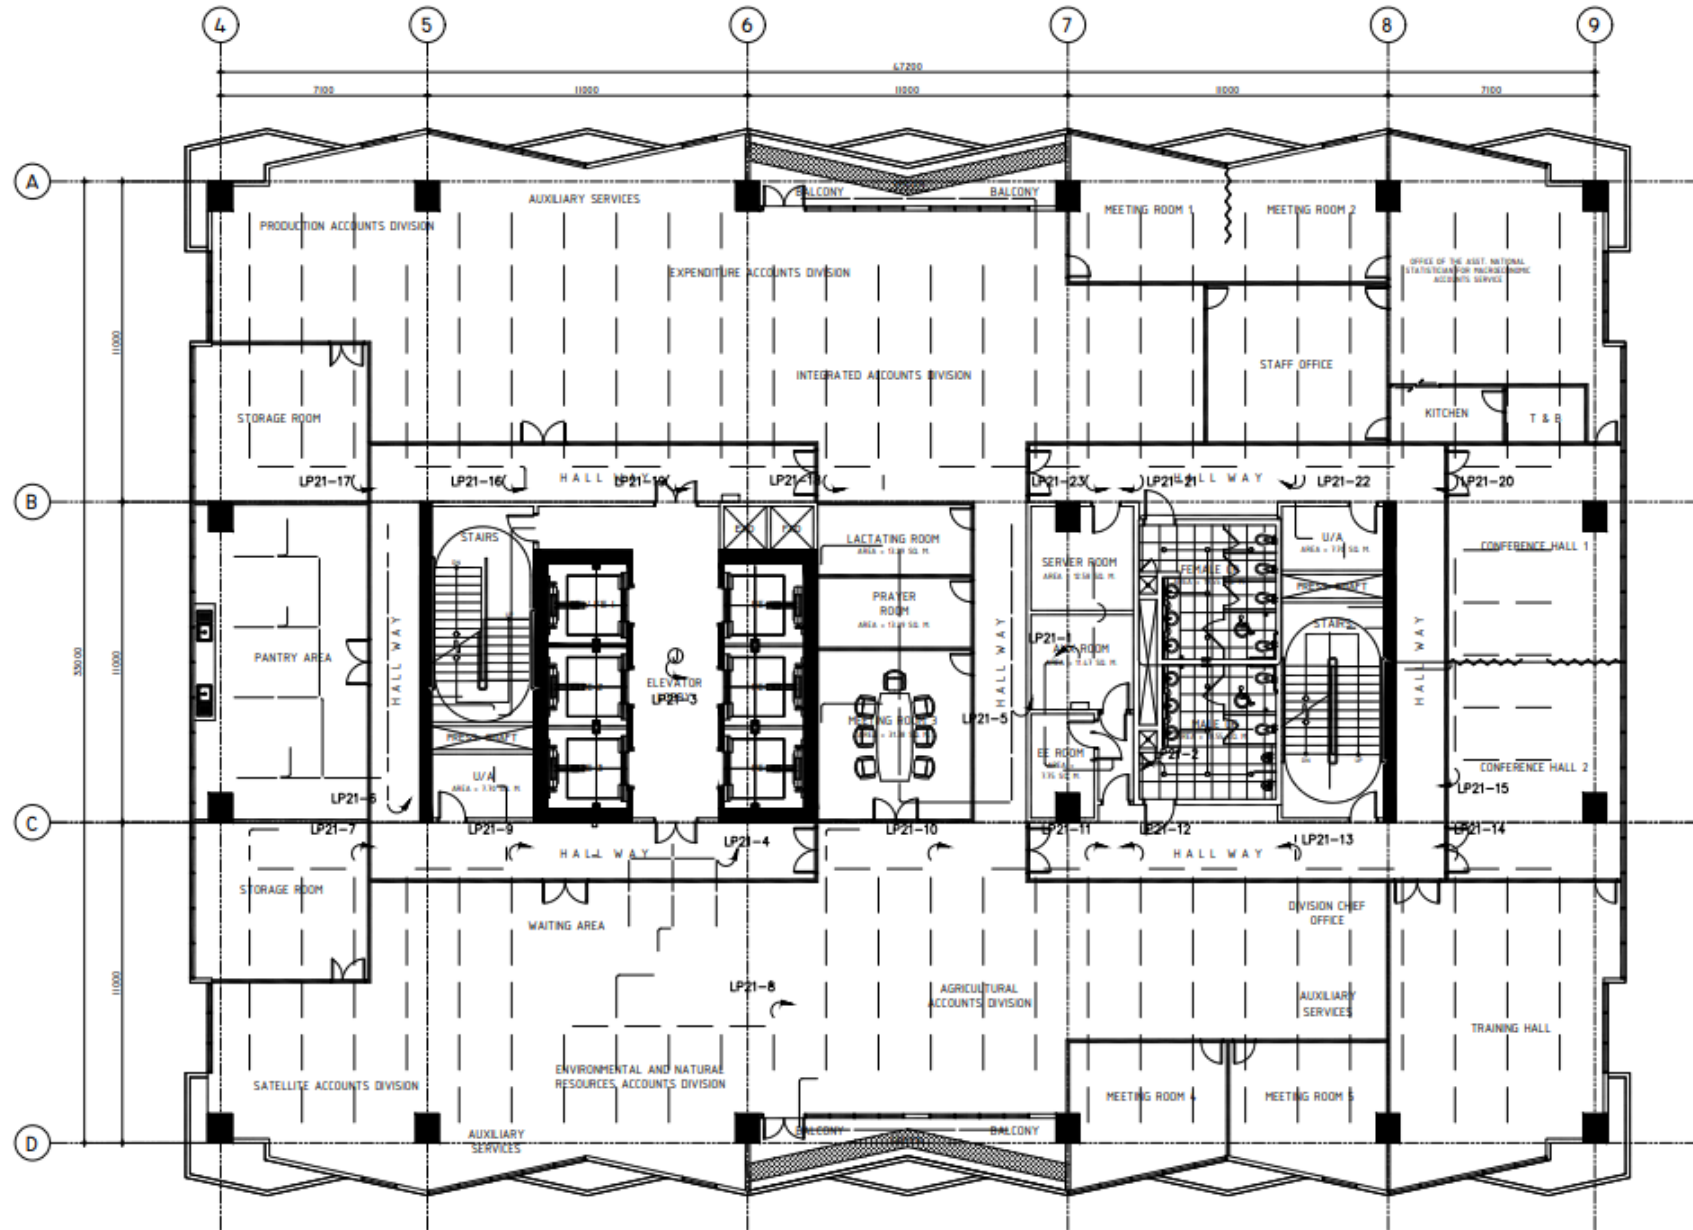

○ LIGHTING LAYOUT
SCALE 1:200 MTS

21st FLOOR


ELECTRICAL PLANS

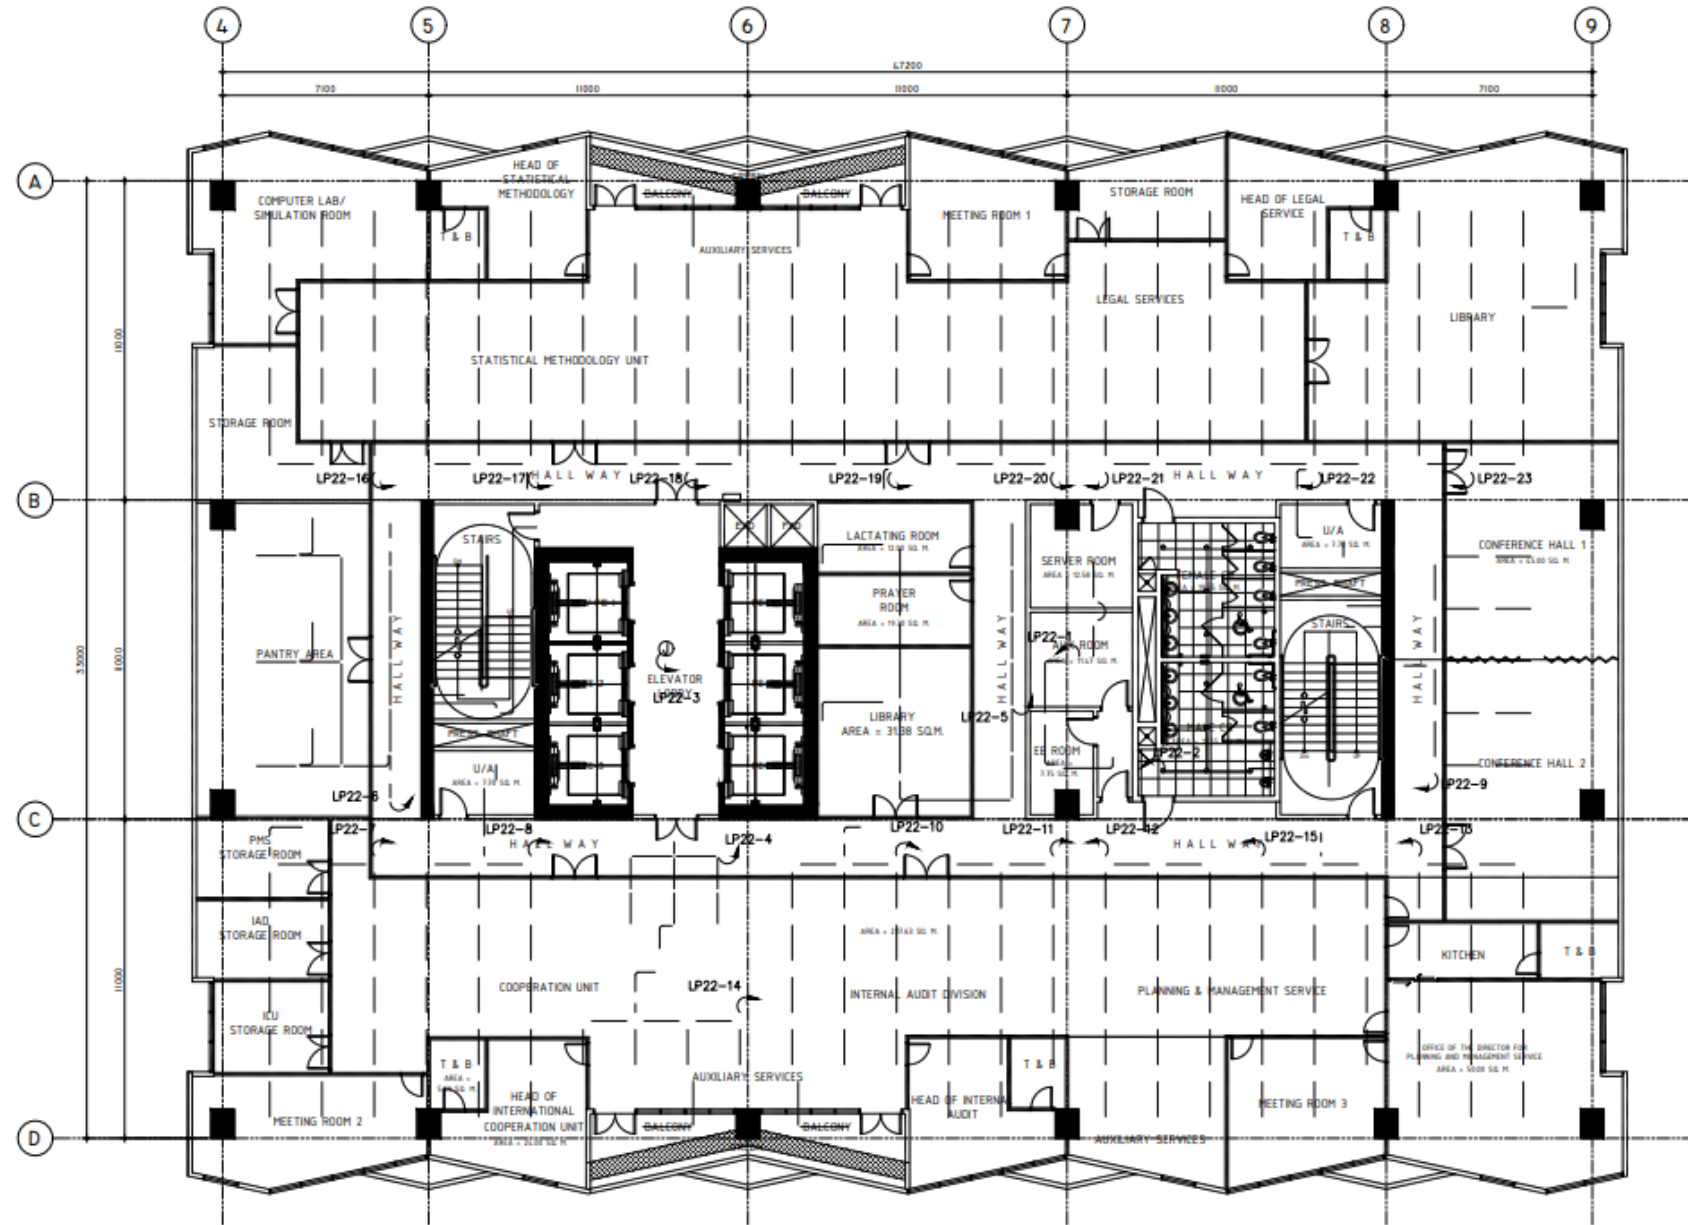

○ LIGHTING LAYOUT
 SCALE 1:200 MTS

22nd FLOOR


ELECTRICAL PLANS

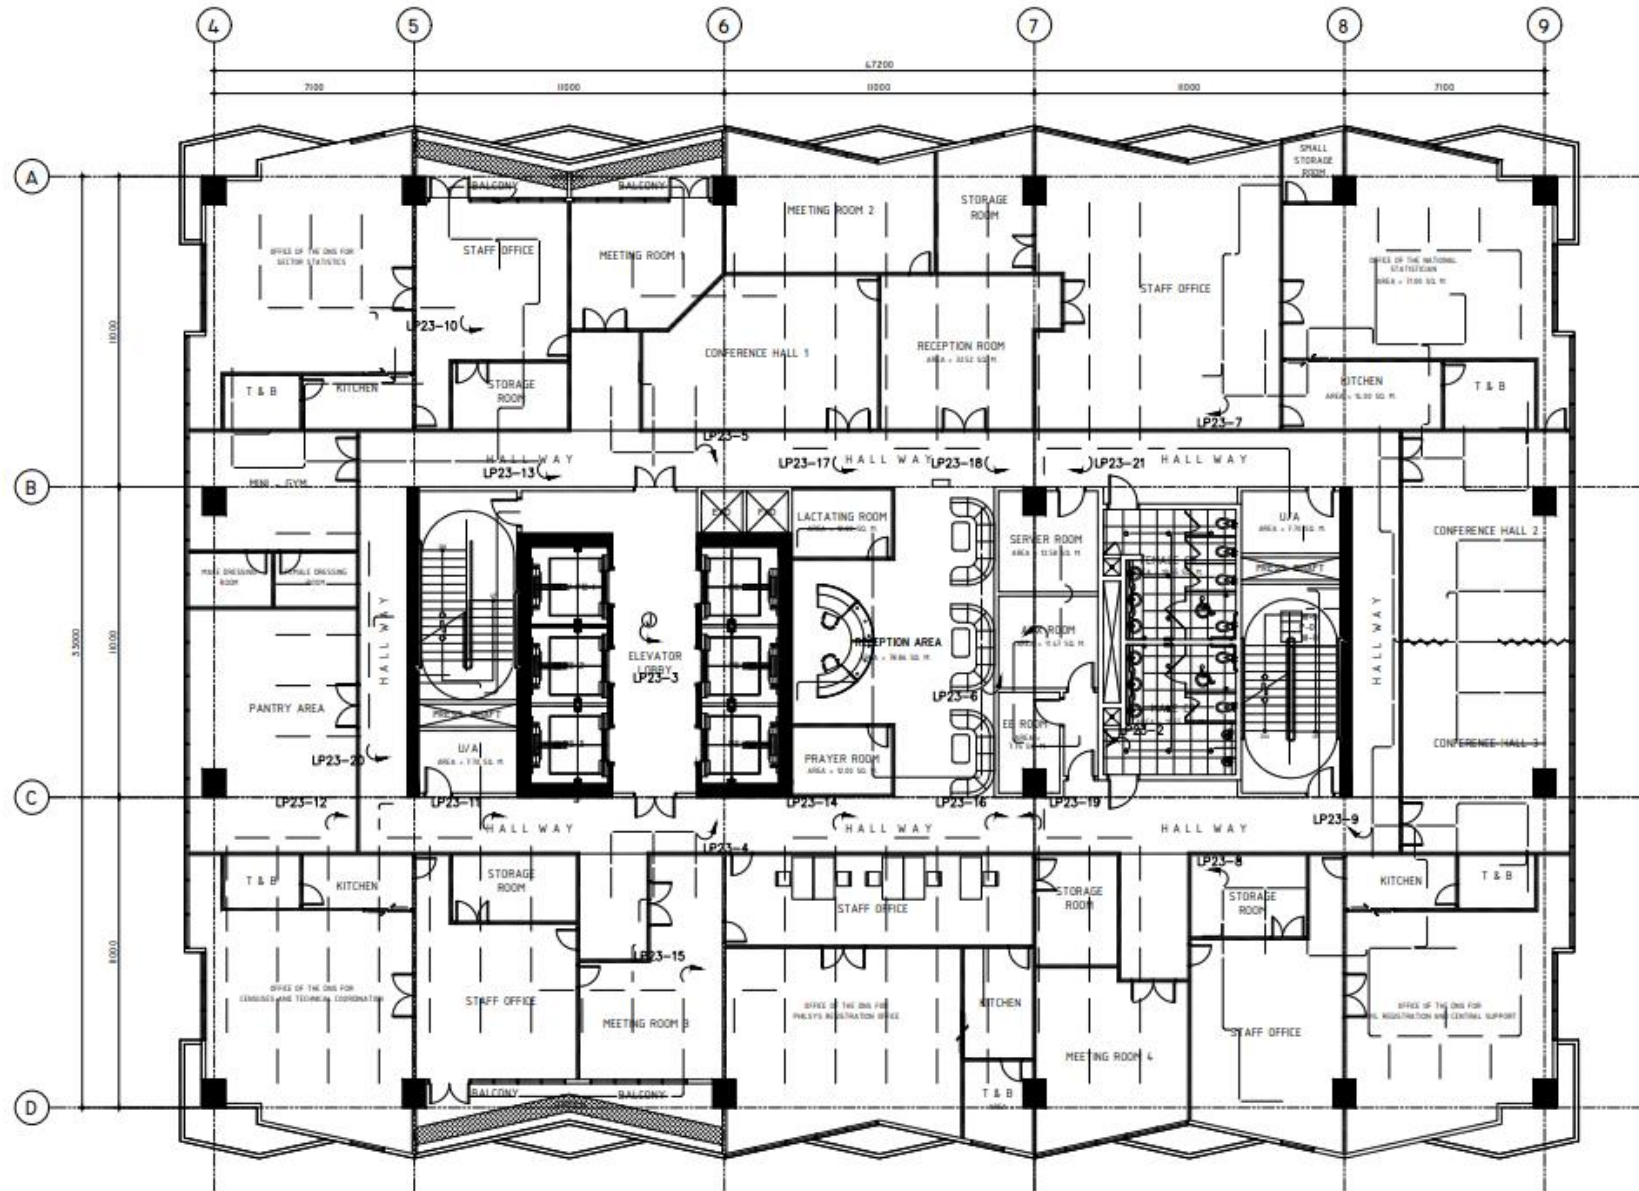

LIGHTING LAYOUT
SCALE 1:200 MTS

23rd FLOOR


ELECTRICAL PLANS

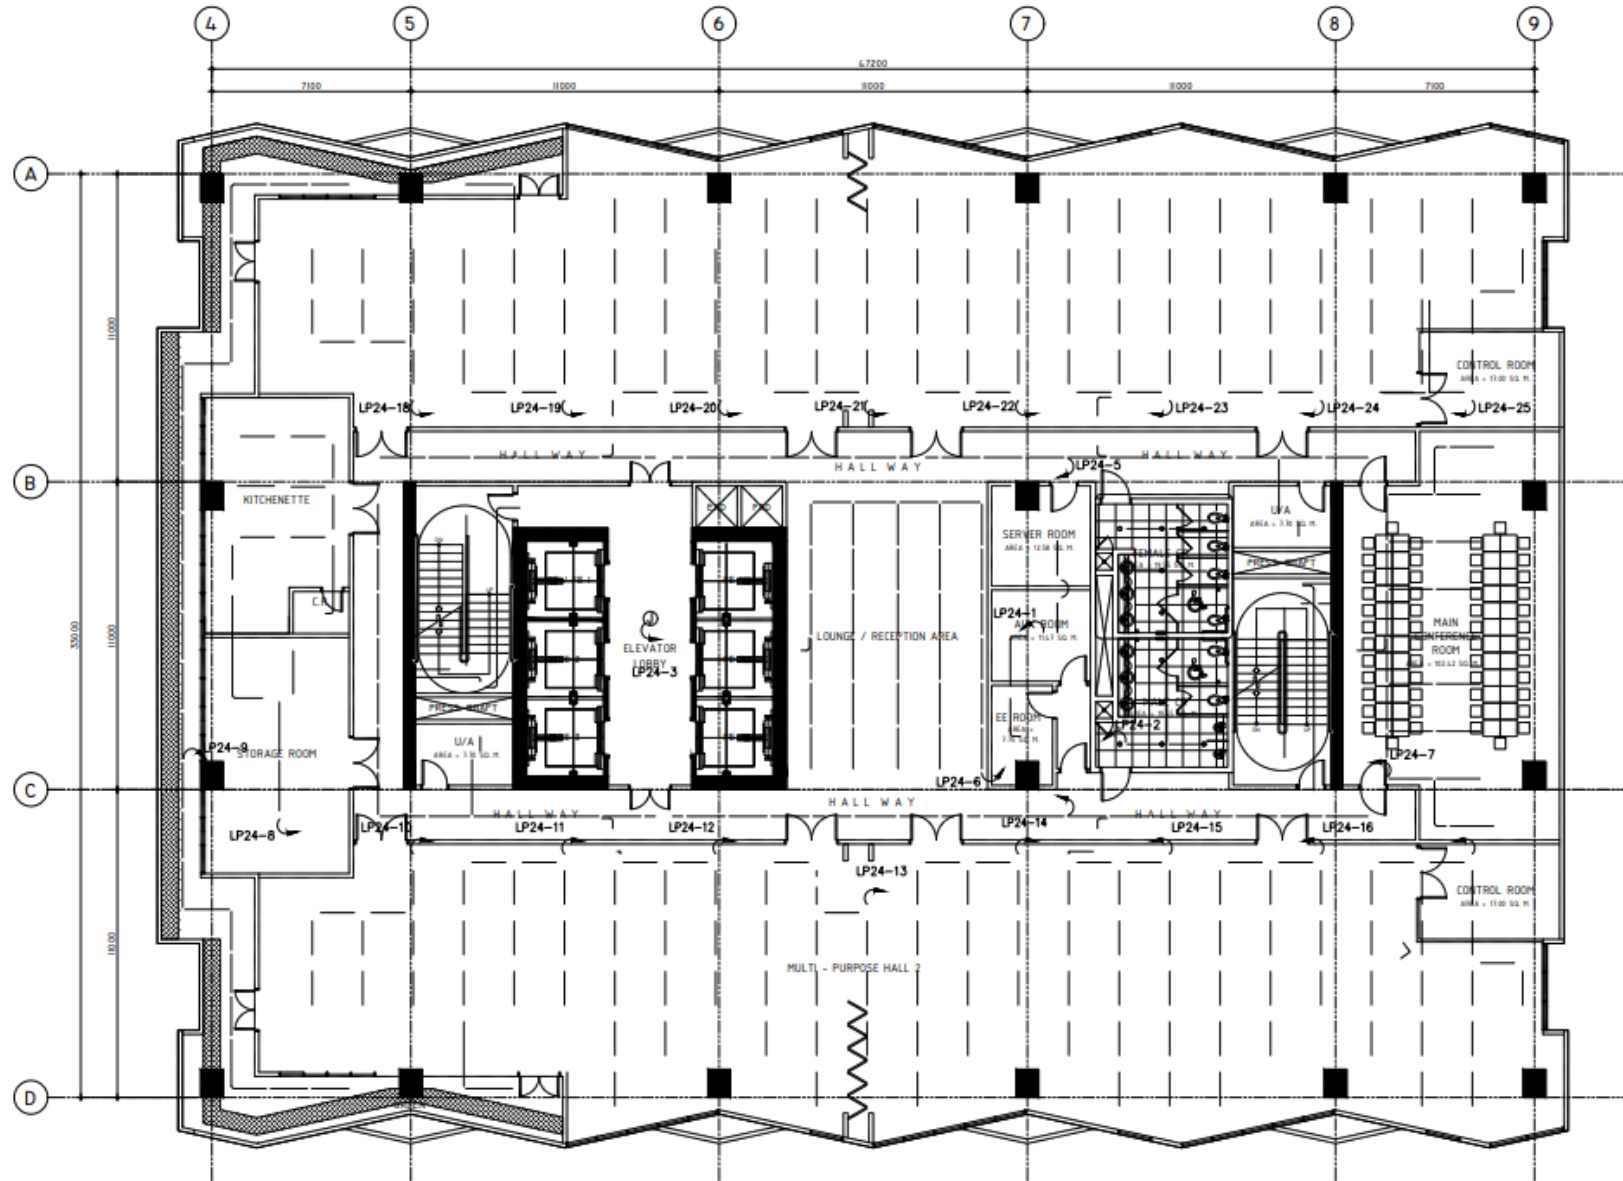

LIGHTING LAYOUT
SCALE 1:200 MTS

24th FLOOR

AUXILIARY WORKS

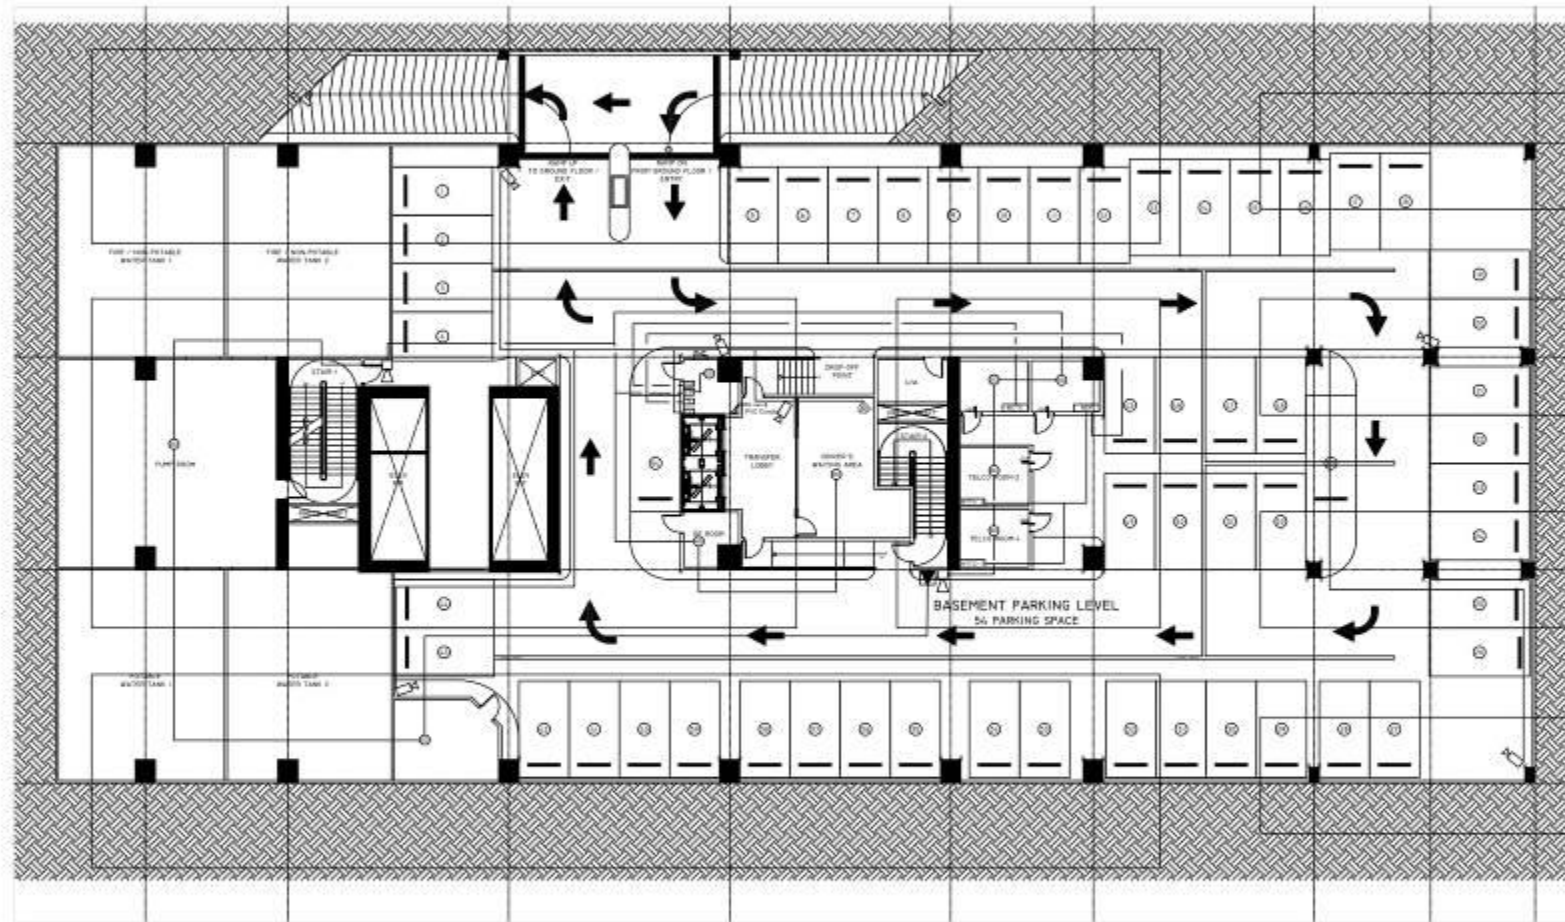


LEGEND	
PA	PULL BOX FOR PABGM SYSTEM
CA	PULL BOX FOR CATV SYSTEM
TL	PULL BOX FOR TELEPHONE SYSTEM
FP	PULL BOX FOR FDAS SYSTEM
CC	PULL BOX FOR CCTV SYSTEM
TTC	TELEPHONE TERMINAL CABINET
CTC	CATV TERMINAL CABINET
CTCC	CCTV TERMINAL CABINET
HD	HEAT DETECTOR
SD	SMOKE DETECTOR
MS	MANUAL PULL STATION
SH	SPEAKER HORN
GA	GRAPHICAL ANNUNCIATOR
FTJ	FIREMAN TELEPHONE JACK
MCTC	MAIN CATV TERMINAL CABINET
MDF	MAIN DISTRIBUTION FRAME
FACP	FIRE ALARM CONTROL PANEL
MTTC	MAIN TELEPHONE TERMINAL CABINET
CMCC	CEILING MOUNTED CCTV CAMERA
WMCC	WALL MOUNTED CCTV CAMERA


AUXILIARY WORKS
 SCALE: 1:250 MTS

TOTAL FLOOR AREA = 3,009.60 sq.m.

BASEMENT

AUXILIARY WORKS

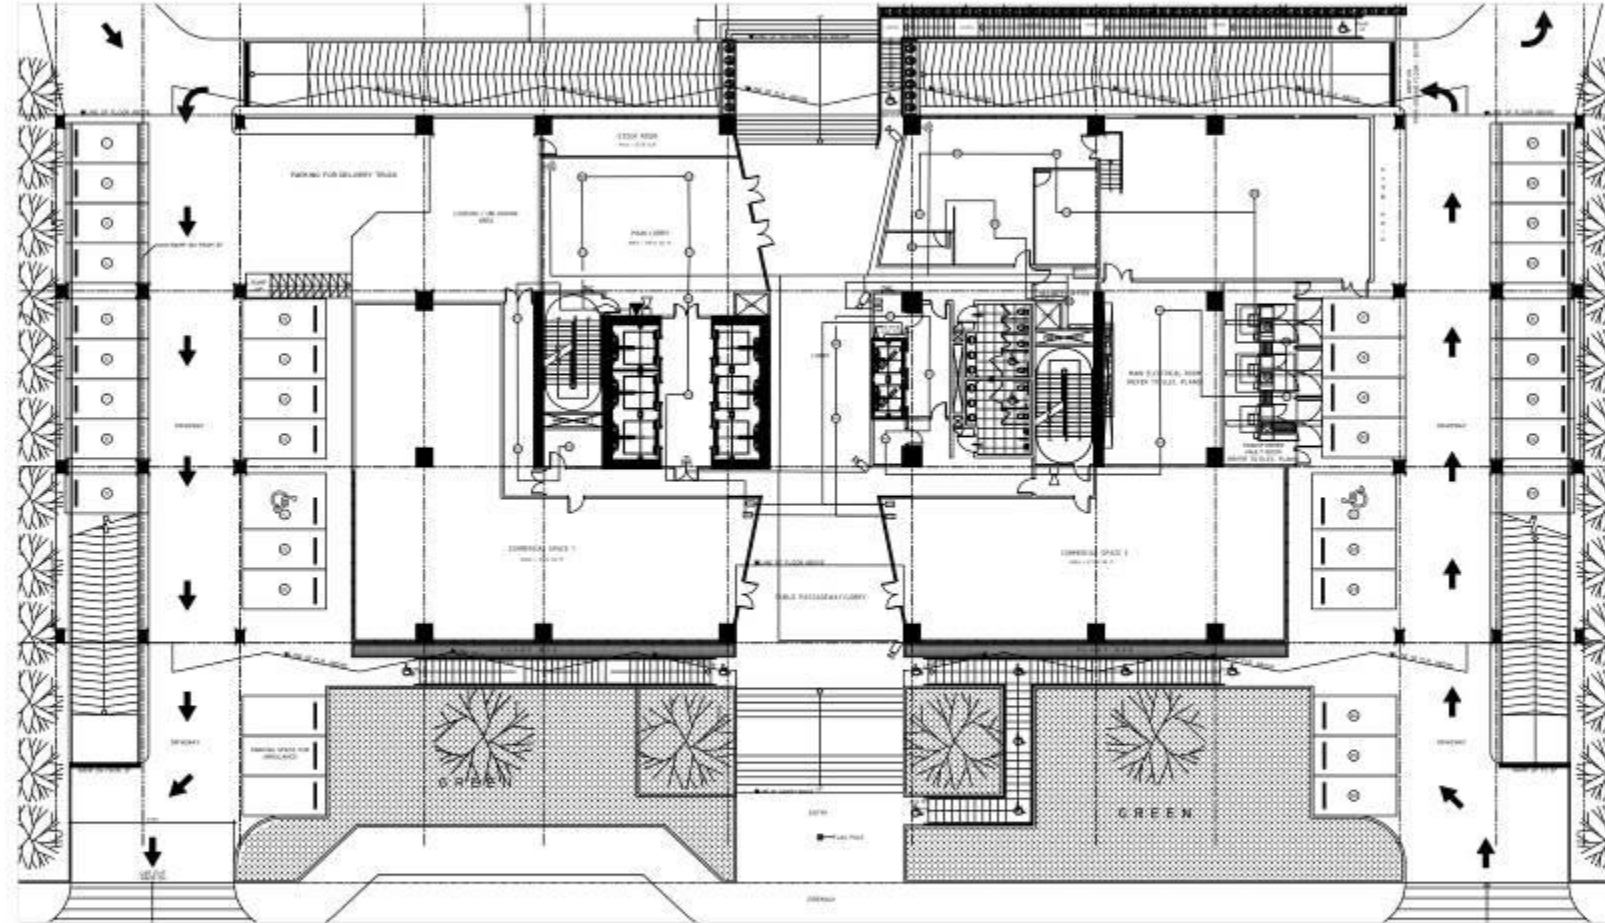


LEGEND	
PA	PULL BOX FOR PABGM SYSTEM
CA	PULL BOX FOR CATV SYSTEM
TL	PULL BOX FOR TELEPHONE SYSTEM
FP	PULL BOX FOR FDAS SYSTEM
CC	PULL BOX FOR CCTV SYSTEM
TTC	TELEPHONE TERMINAL CABINET
CTC	CATV TERMINAL CABINET
CTCC	CCTV TERMINAL CABINET
HD	HEAT DETECTOR
SD	SMOKE DETECTOR
MS	MANUAL PULL STATION
SH	SPEAKER HORN
GA	GRAPHICAL ANNUNCIATOR
FJT	FIREMAN TELEPHONE JACK
MCTC	MAIN CATV TERMINAL CABINET
MDF	MAIN DISTRIBUTION FRAME
FACP	FIRE ALARM CONTROL PANEL
MTTC	MAIN TELEPHONE TERMINAL CABINET
CMCC	CEILING MOUNTED CCTV CAMERA
WMCC	WALL MOUNTED CCTV CAMERA


AUXILIARY WORKS
 SCALE: 1:250 MTS

TOTAL FLOOR AREA = 3,009.60 sq.m.
GROUND FLOOR

AUXILIARY WORKS

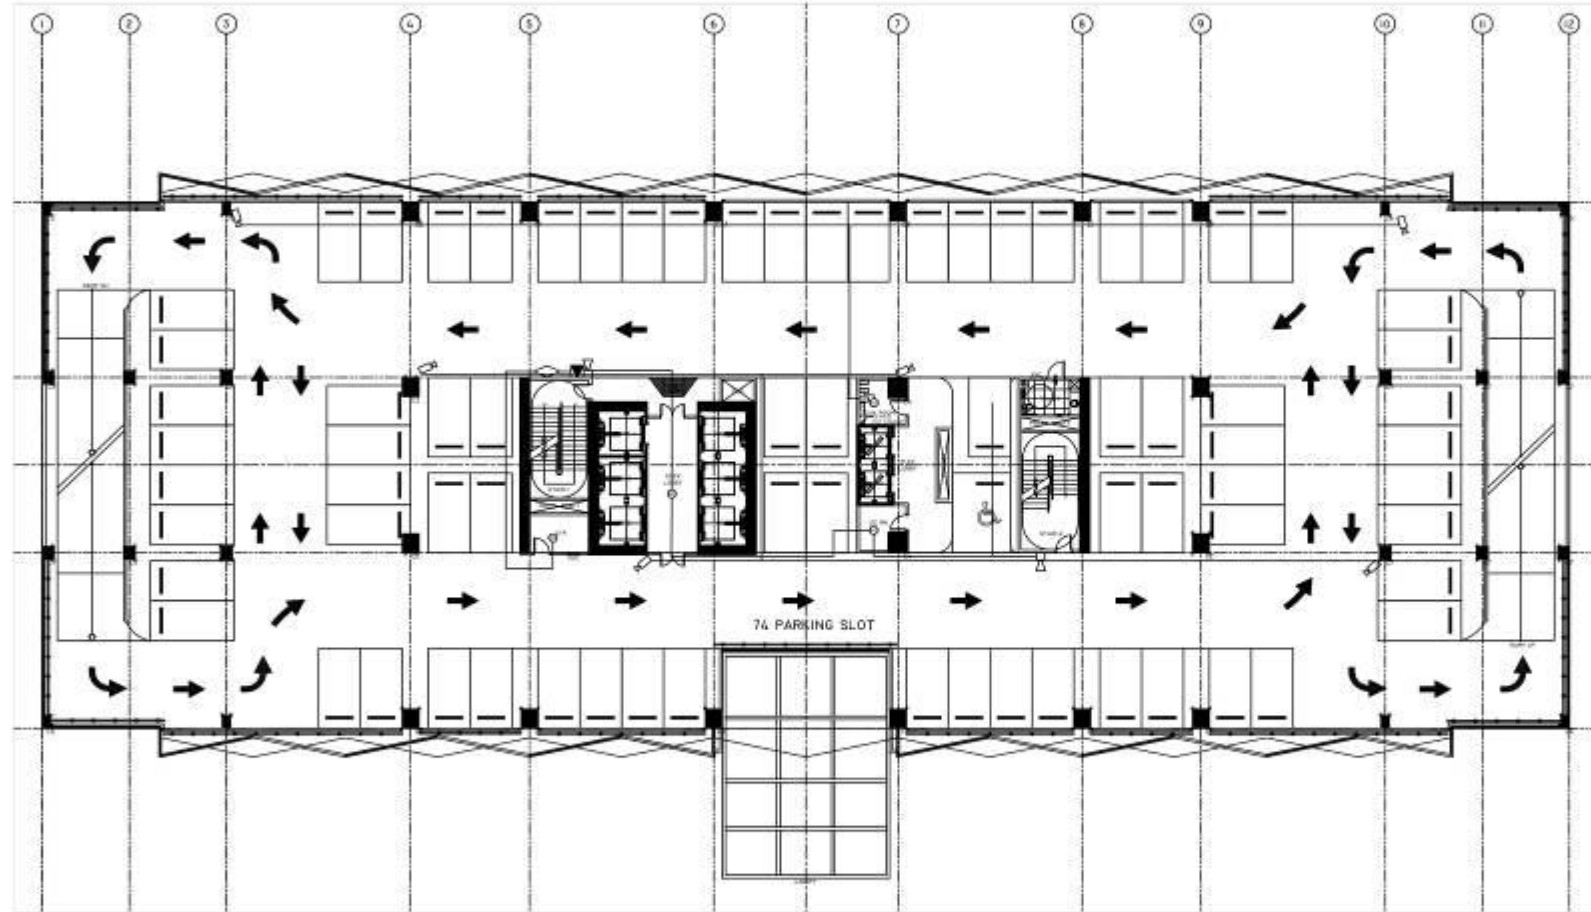


LEGEND	
PA	PULL BOX FOR PABGM SYSTEM
CA	PULL BOX FOR CATV SYSTEM
TL	PULL BOX FOR TELEPHONE SYSTEM
FP	PULL BOX FOR FDAS SYSTEM
CC	PULL BOX FOR CCTV SYSTEM
TTTC	TELEPHONE TERMINAL CABINET
CTC	CATV TERMINAL CABINET
CTCC	CCTV TERMINAL CABINET
HD	HEAT DETECTOR
SD	SMOKE DETECTOR
MS	MANUAL PULL STATION
SH	SPEAKER HORN
GA	GRAPHICAL ANNUNCIATOR
FJT	FIREMAN TELEPHONE JACK
MCTC	MAIN CATV TERMINAL CABINET
MDF	MAIN DISTRIBUTION FRAME
FACP	FIRE ALARM CONTROL PANEL
MTTC	MAIN TELEPHONE TERMINAL CABINET
CMCC	CEILING MOUNTED CCTV CAMERA
WMCC	WALL MOUNTED CCTV CAMERA


AUXILIARY WORKS
 SCALE: 1:250 MTS

TOTAL FLOOR AREA = 3,009.60 sq.m.

2nd FLOOR

AUXILIARY WORKS

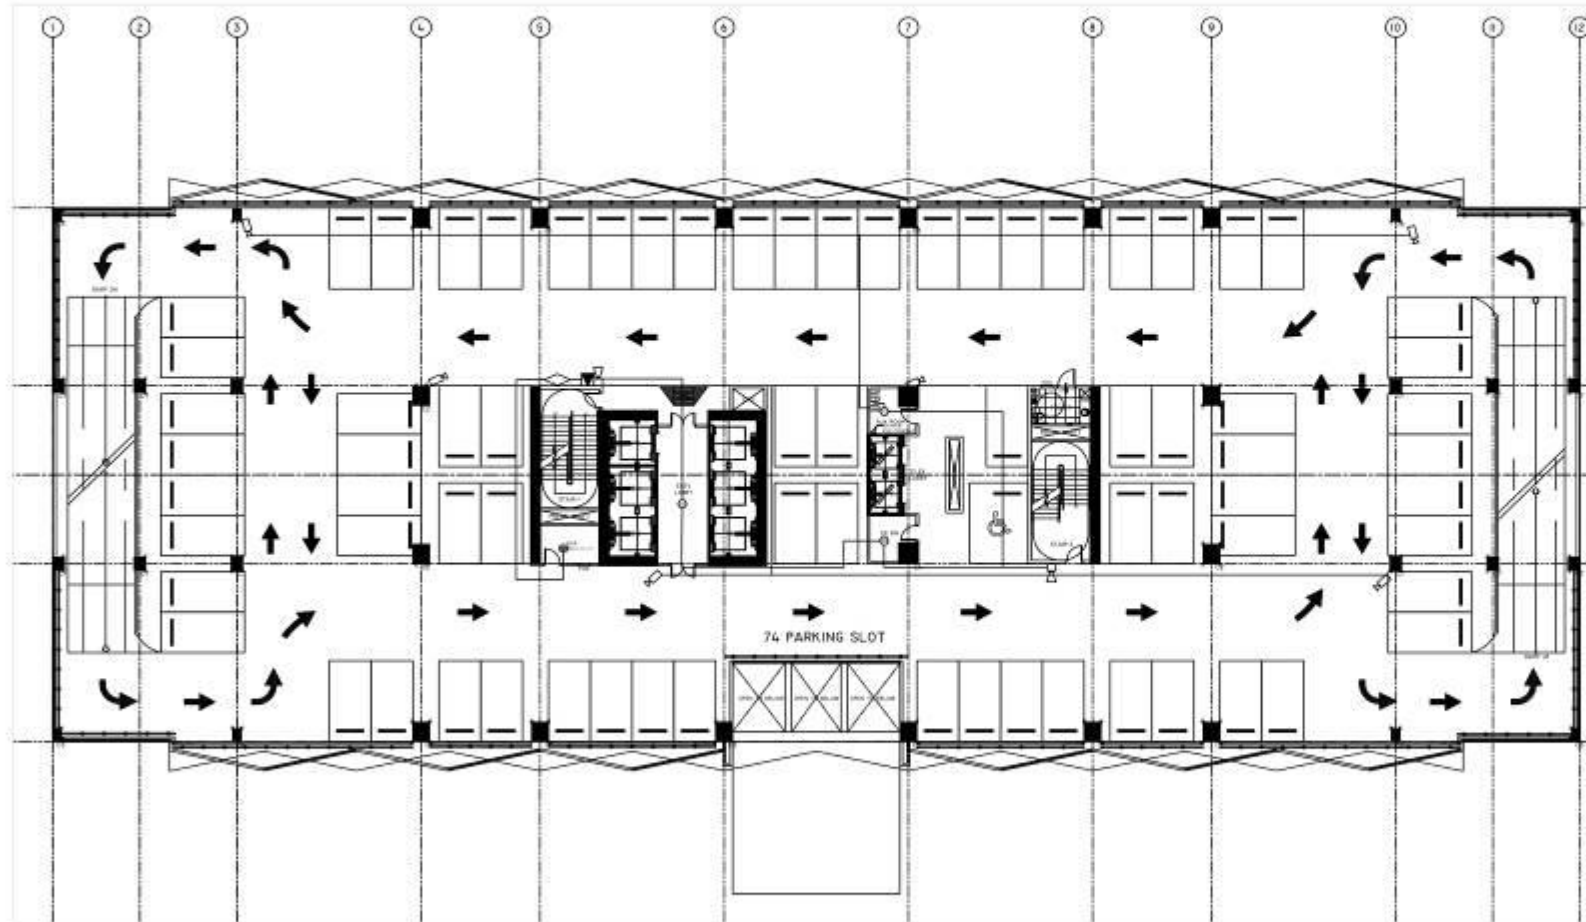


LEGEND	
PA	PULL BOX FOR PABGM SYSTEM
CA	PULL BOX FOR CATV SYSTEM
TL	PULL BOX FOR TELEPHONE SYSTEM
FP	PULL BOX FOR FDAS SYSTEM
CC	PULL BOX FOR CCTV SYSTEM
TTC	TELEPHONE TERMINAL CABINET
CTC	CATV TERMINAL CABINET
CTC	CCTV TERMINAL CABINET
HD	HEAT DETECTOR
SD	SMOKE DETECTOR
□	MANUAL PULL STATION
◇	SPEAKER HORN
◇	GRAPHICAL ANNUNCIATOR
▽	FIREMAN TELEPHONE JACK
MCTC	MAIN CATV TERMINAL CABINET
MDF	MAIN DISTRIBUTION FRAME
FACP	FIRE ALARM CONTROL PANEL
MTTC	MAIN TELEPHONE TERMINAL CABINET
□	CEILING MOUNTED CCTV CAMERA
□	WALL MOUNTED CCTV CAMERA

AUXILIARY WORKS
 SCALE: 1:250 MTS

TOTAL FLOOR AREA = 3,009.60 sq.m.

3rd FLOOR

AUXILIARY WORKS

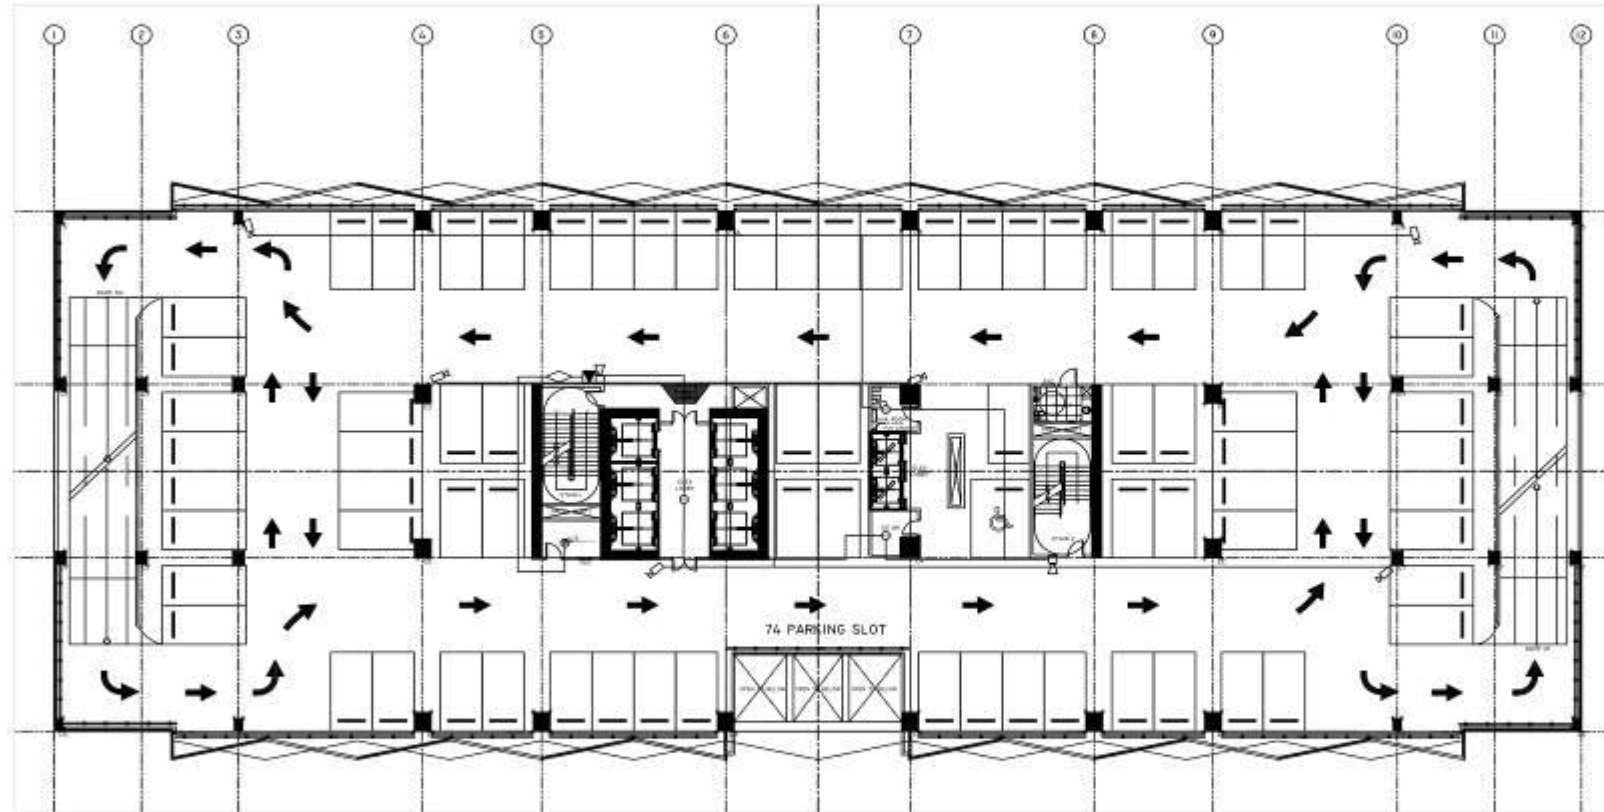

LEGEND	
PA	PULL BOX FOR PABGM SYSTEM
CA	PULL BOX FOR CATV SYSTEM
TL	PULL BOX FOR TELEPHONE SYSTEM
FP	PULL BOX FOR FDAS SYSTEM
CC	PULL BOX FOR CCTV SYSTEM
ITC	TELEPHONE TERMINAL CABINET
CTC	CATV TERMINAL CABINET
CTC	CCTV TERMINAL CABINET
HD	HEAT DETECTOR
SD	SMOKE DETECTOR
MP	MANUAL PULL STATION
SH	SPEAKER HORN
GA	GRAPHICAL ANNUNCIATOR
FJT	FIREMAN TELEPHONE JACK
MCTC	MAIN CATV TERMINAL CABINET
MDF	MAIN DISTRIBUTION FRAME
FACP	FIRE ALARM CONTROL PANEL
MTTC	MAIN TELEPHONE TERMINAL CABINET
CMCC	CEILING MOUNTED CCTV CAMERA
WMCC	WALL MOUNTED CCTV CAMERA


AUXILIARY WORKS
 SCALE: 1:250 MTS

TOTAL FLOOR AREA = 3,009.60 sq.m.

4th FLOOR